

NAME OF SCHOOL

MAYOR

CITY COMMISSION

MEMBERS, BOARD OF TRUSTEES

ARCHITECT

ELECTRICAL ENGR.

MECHANICAL ENGR.

STRUCTURAL ENGR.

GENERAL CONTRACTOR

PLUMBING CONTRACTOR

ELECTRICAL CONTRACTOR

JOB SIGN

THIS CONTRACTOR TO FURNISH AND ERECT
WERE DIRECTED BY THE ARCHITECT. A
10'x80' SIGN, MOUNTED ON 4"x4" POST
ANCHORED SECURELY IN THE GROUND.
SUBMIT SHOP DRAWING.

A-FLUSH MOUNTED STANDING
FULL HEIGHT SPEC. R WITH
6-5/8" SHIRT BRACKET FOR
10" SUCIVES EA. UNIT.
K 8" V. RE APPROVAL EPOCH.

ELEVATION SCALE 3/8"=1'-0"

4'-0" 4'-0"

8'-3 3/4"


DISPLAY CASE PLAN - SCALE 3/8"=1'-0"

EXISTING CURB TO REMAIN


FLOOR PLAN
SCALE 1/8"=1'-0"

PARKING AREA
EXISTING CURB TO REMAIN



NOTE: CONTRACTOR SHALL VERIFY ALL DIMENSIONS ON THE PROJECT	
ALTERATIONS & ADDITIONS TO	COMM. INC.
MARSHALL ELEMENTARY SCHOOL	2322
2909 OAK FOREST DRIVE, JACKSON, MISS.	DATE 4/1/66
BURTON & STAATS A.I.A.	DRN. 2/1/66
ARCHITECTS & CONSULTING DESIGNERS	CKD. 4/5
4503 OFFICE PARK, JACKSON, MISSISSIPPI	REV.
FLOOR PLAN	A2

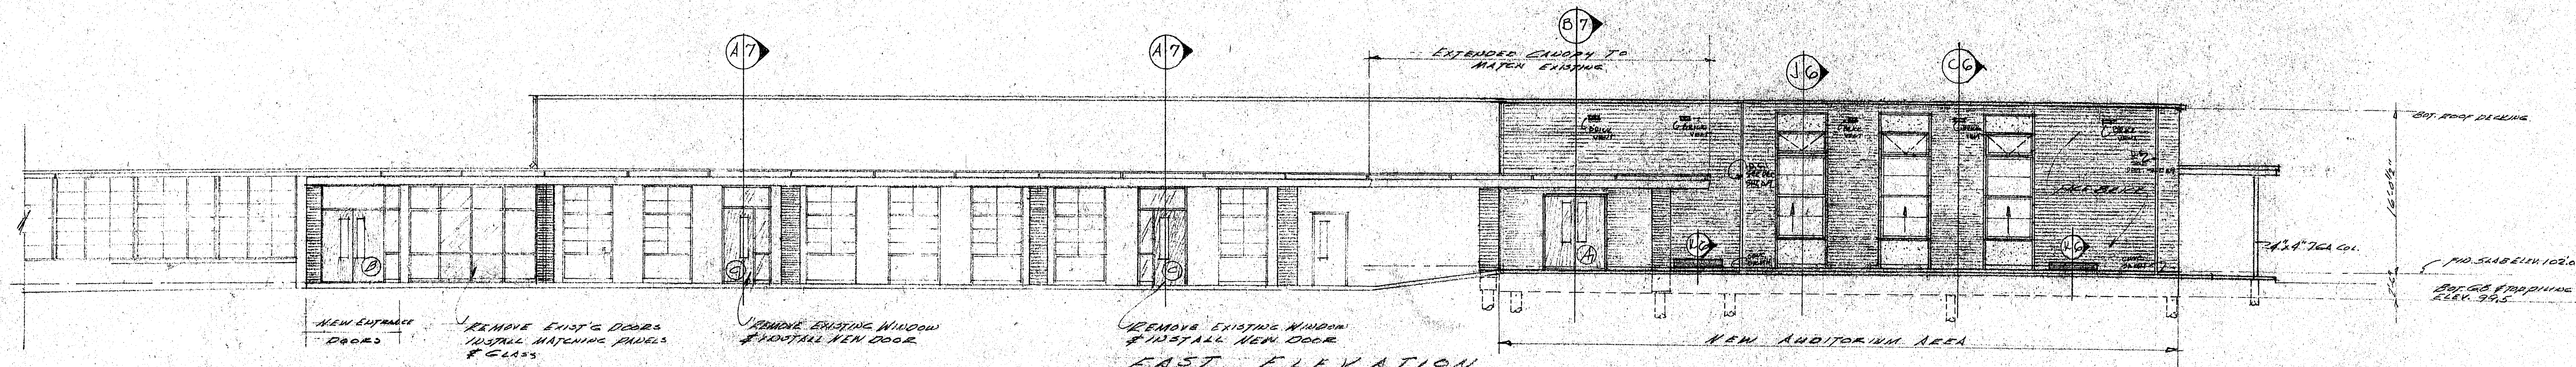


EAST ELEVATION
SCALE 1/8"=1'-0"

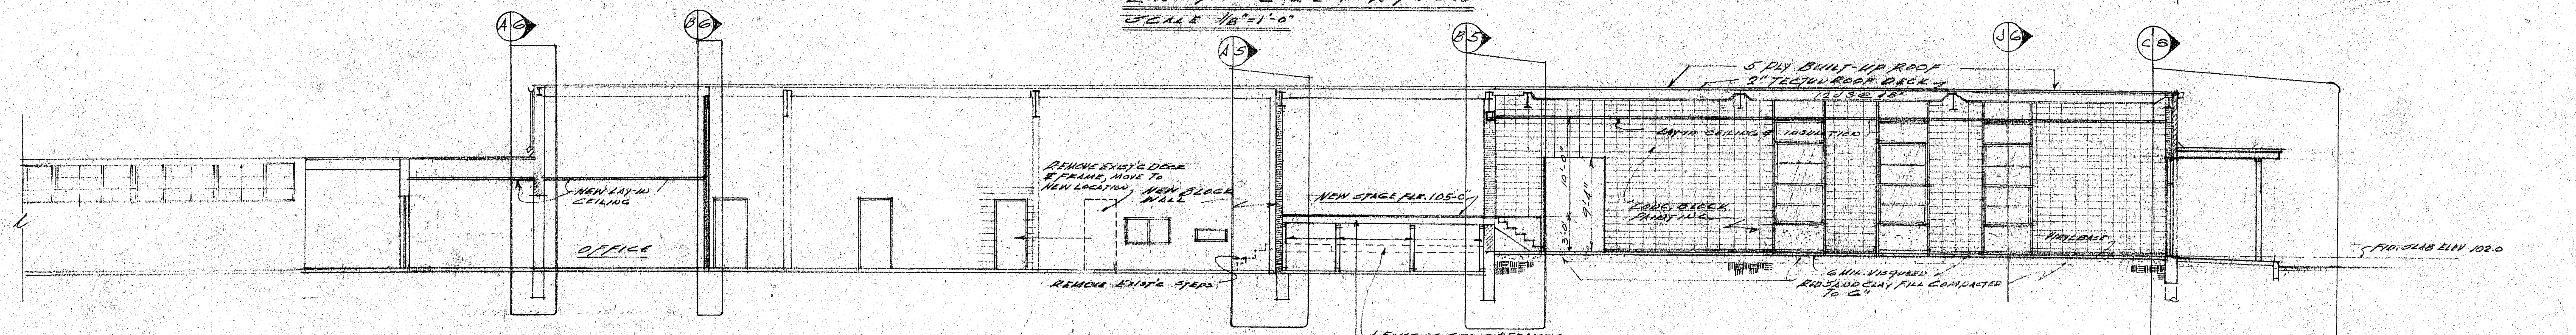


SECTION
SCALE 1/8"=1'-0"

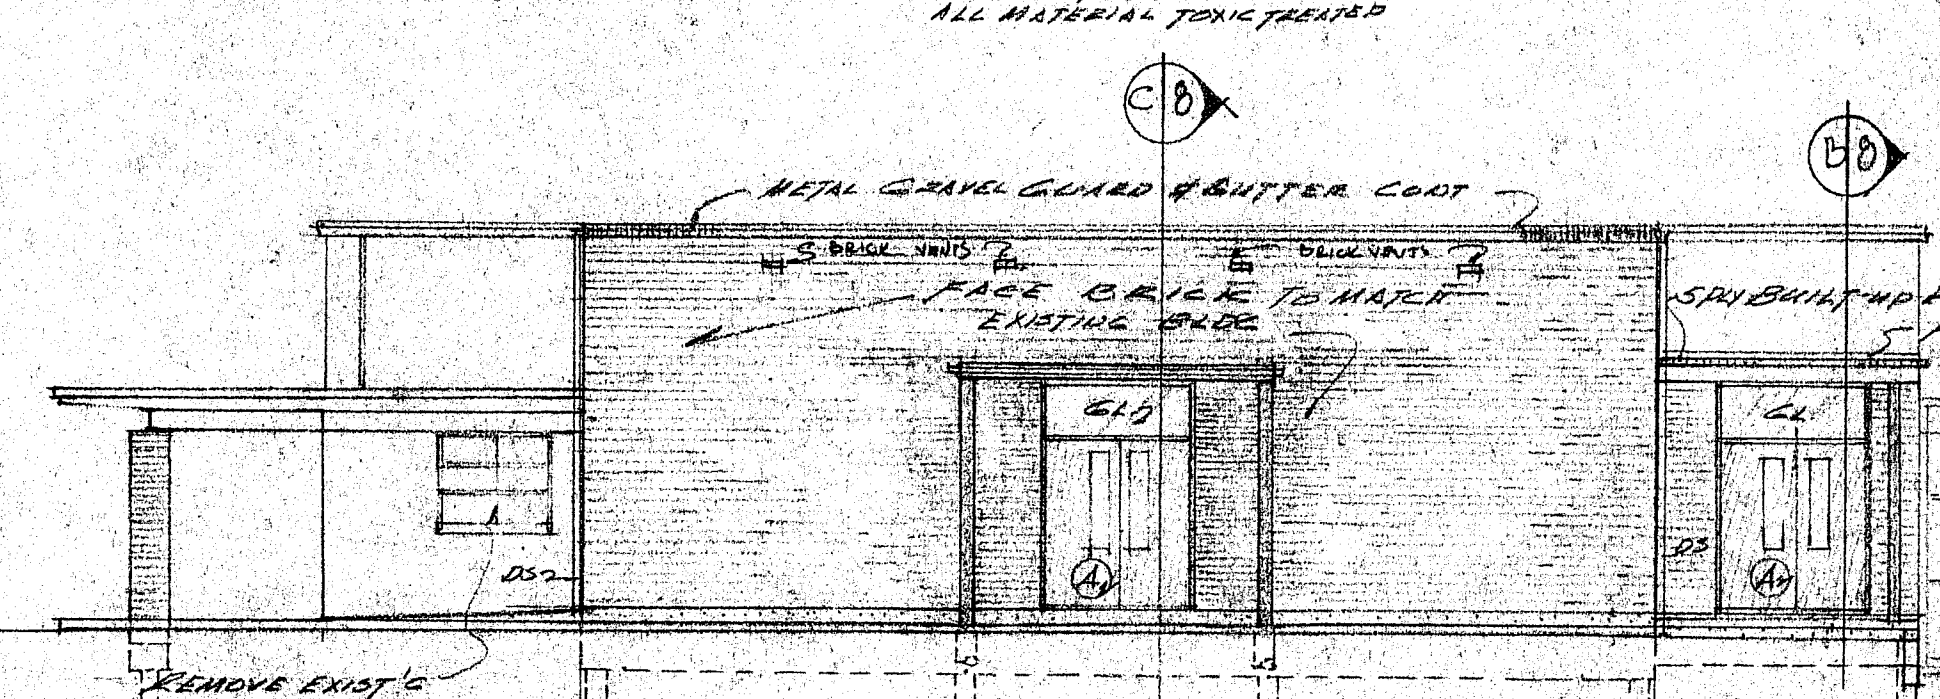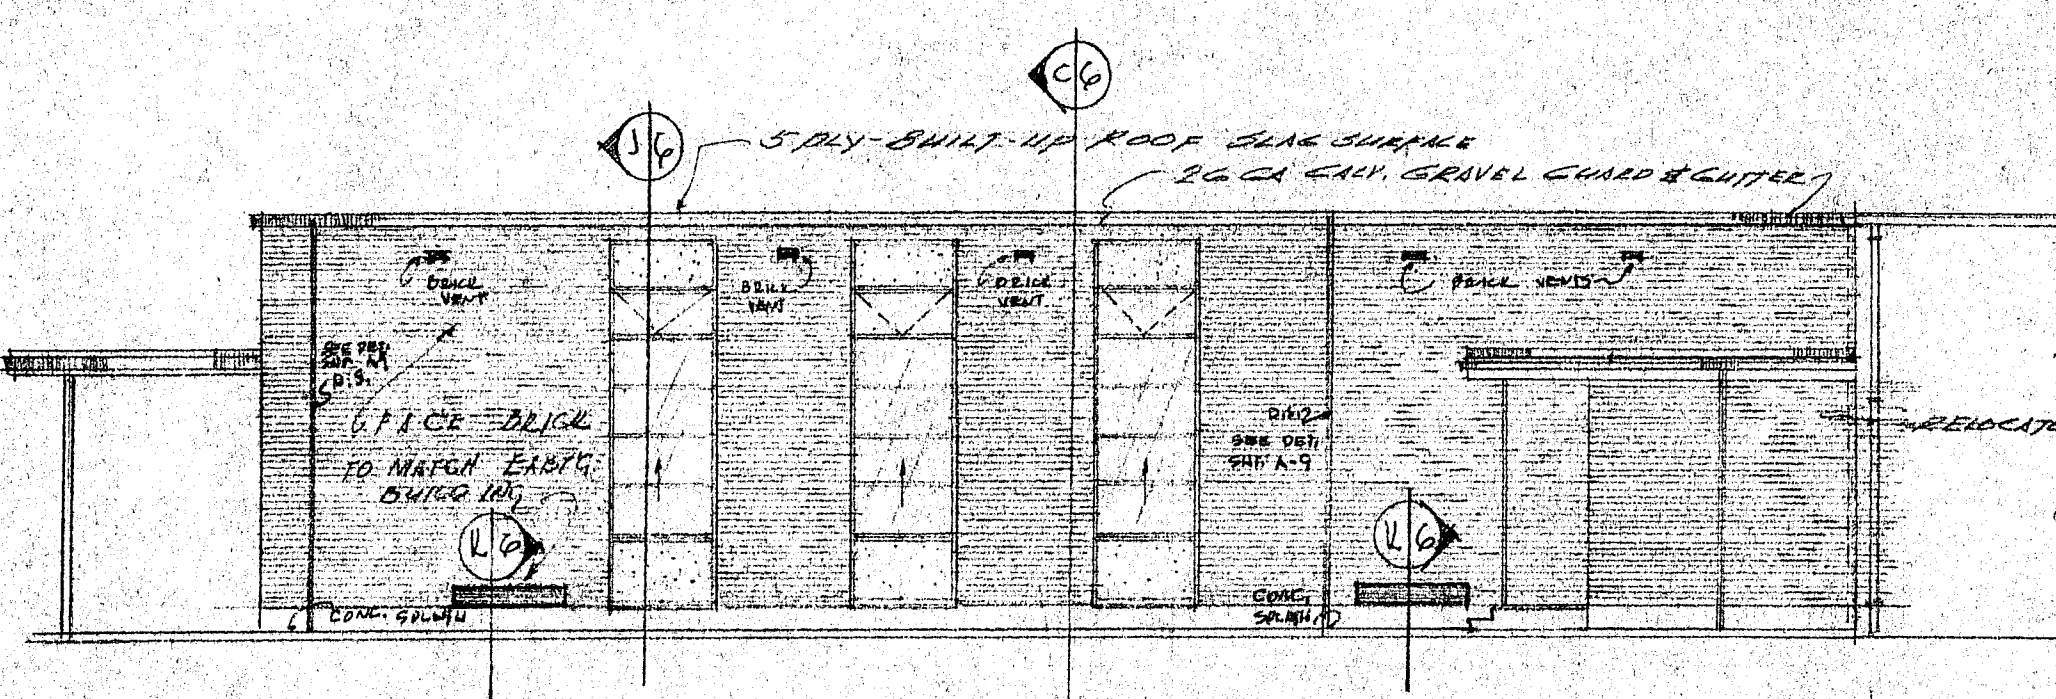


NORTH ELEV. AUDITORIUM
SCALE 1/8"=1'-0"

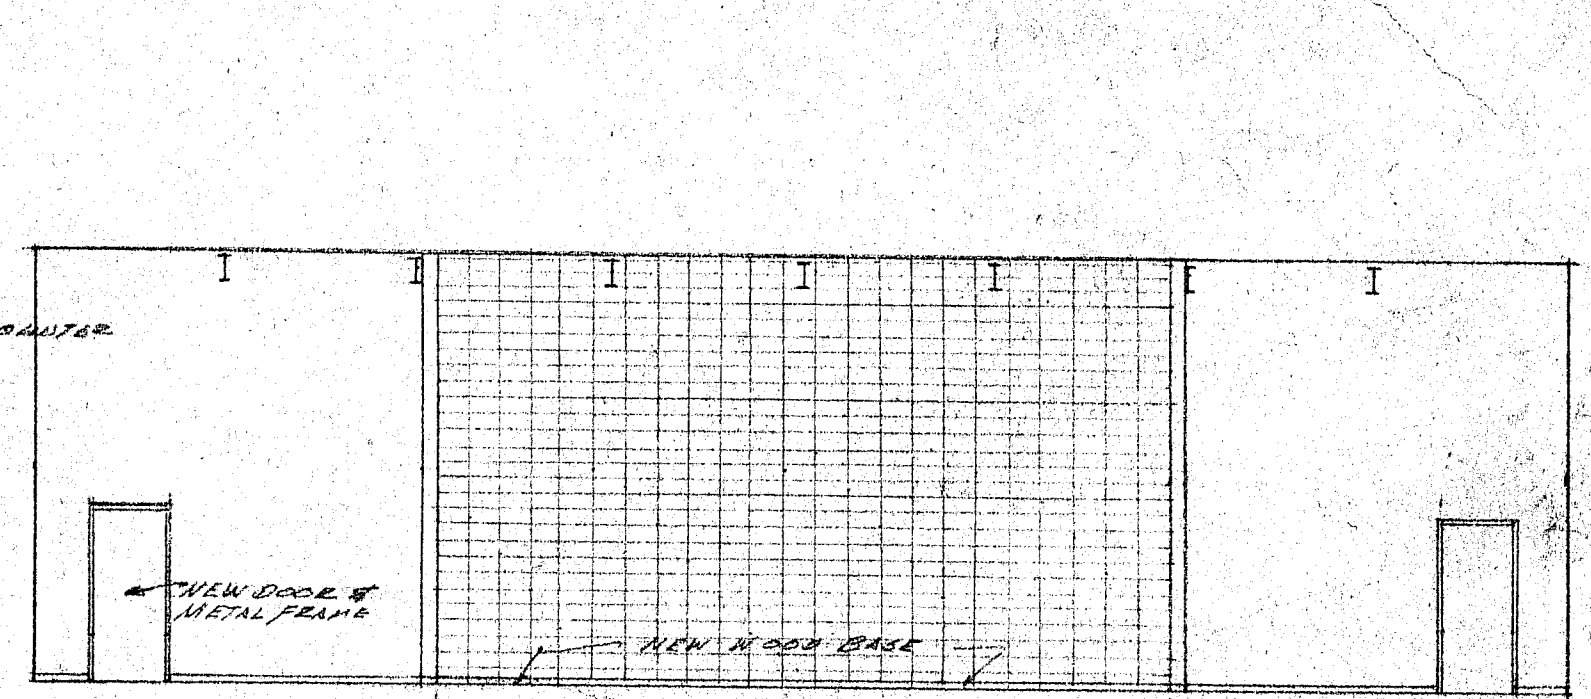


EXISTING STAGE WALL
SCALE 1/8"=1'-0"

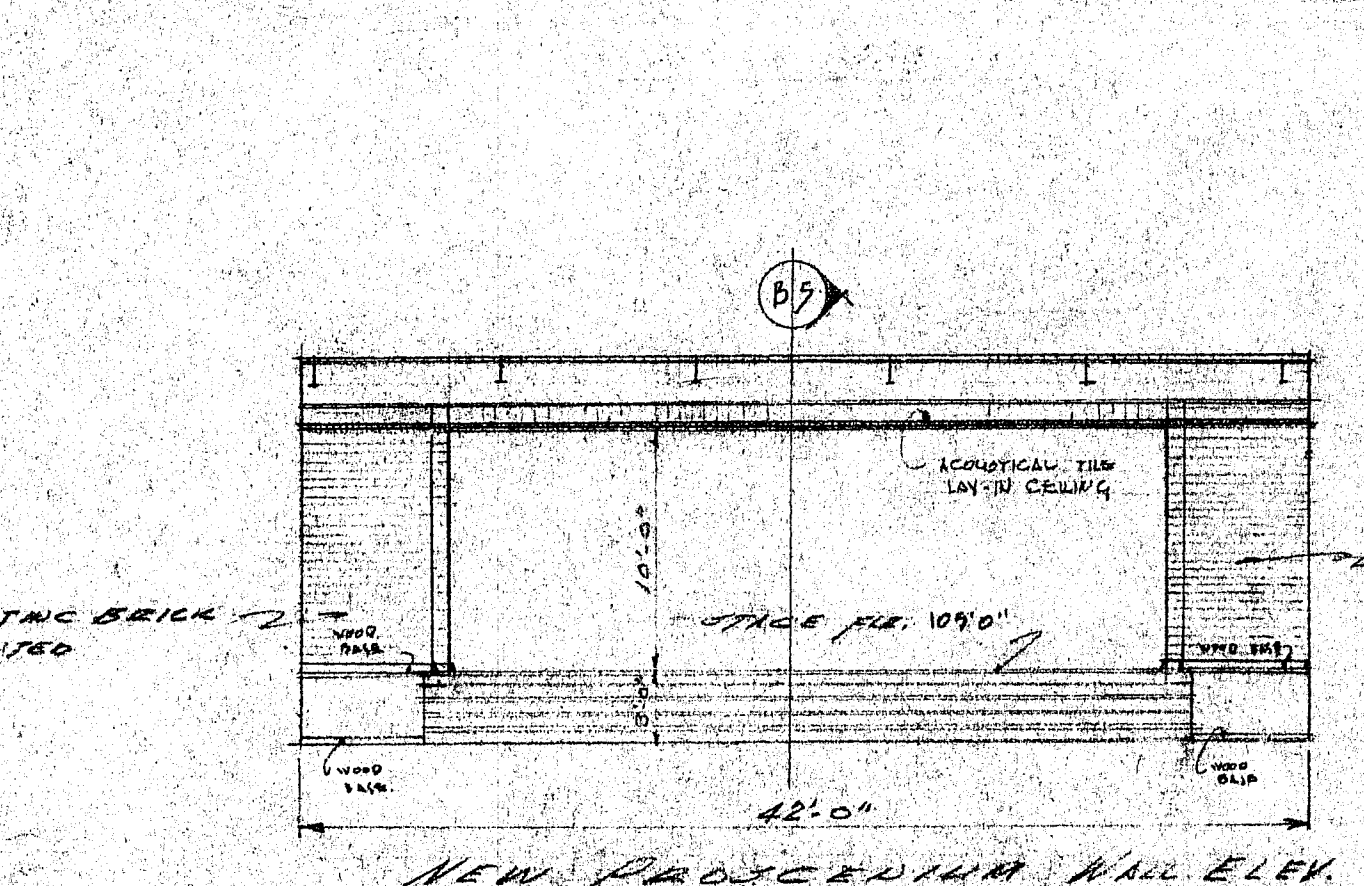

NEW PROJECTION WALL ELEV.
SCALE 1/8"=1'-0"

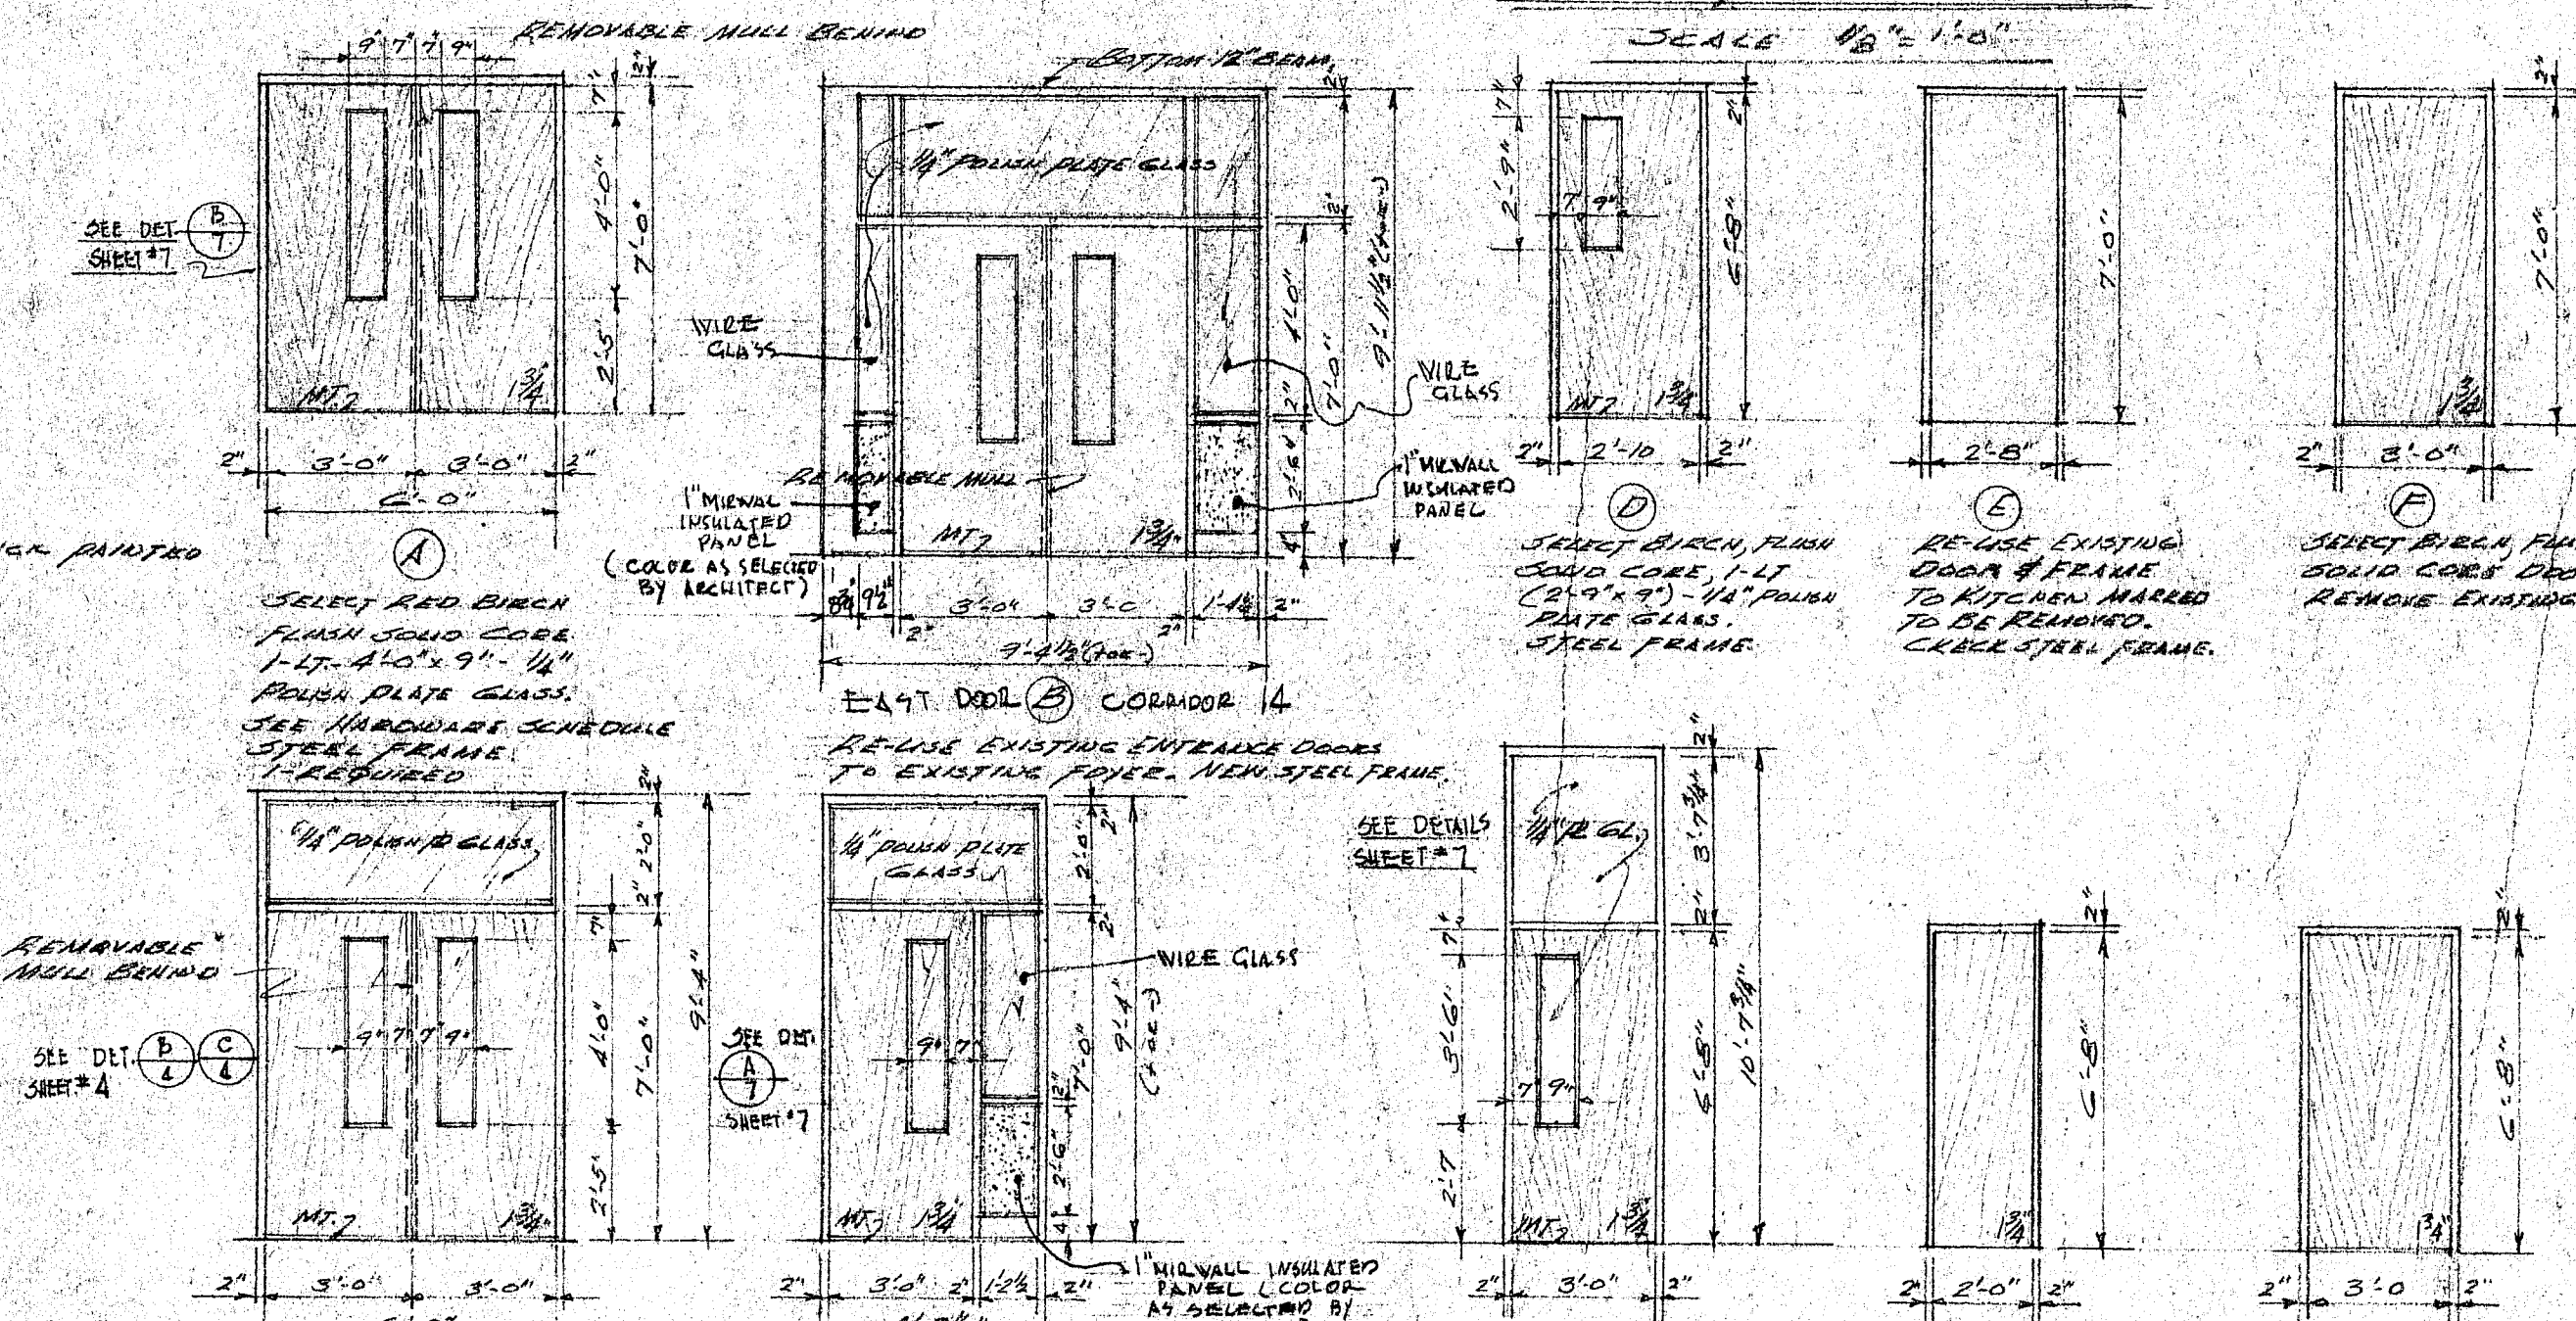


DOOR & FRAME SCHEDULE - SCALE 1/4"=1'-0"

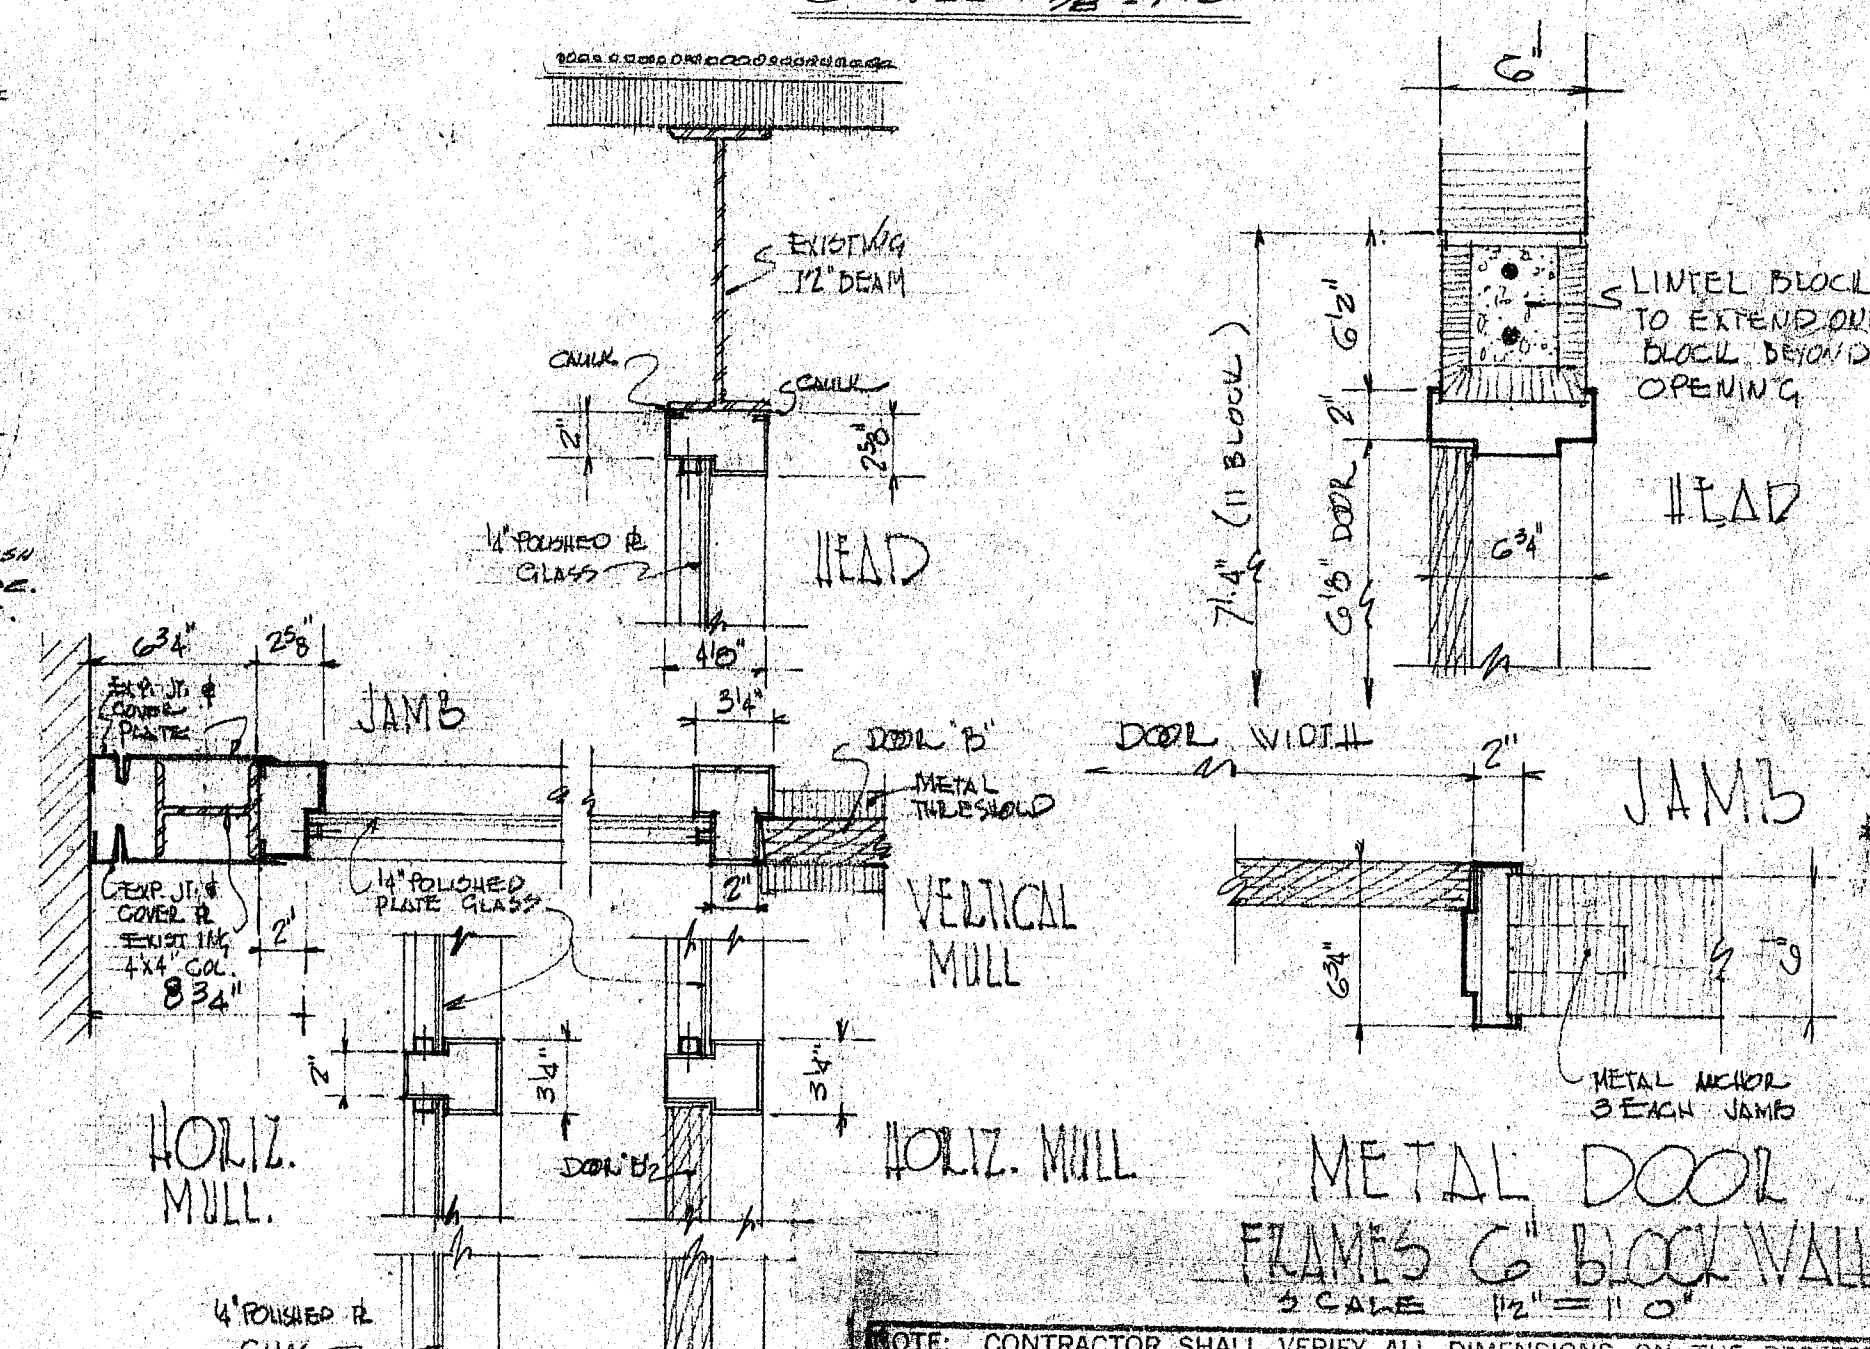

NOTE: CONTRACTOR SHALL VERIFY ALL DIMENSIONS ON THE PROJECT

ALTERATIONS & ADDITION TO MARSHALL ELEMENTARY SCHOOL		COMM. NO. 6323
2909 OAK FOREST DRIVE, JACKSON, MISS.		DATE 4/1/68
BURTON & STAATS A.I.A. ARCHITECTS & CONSULTING DESIGNERS		DRN. 11/5
1503 OFFICE BLDG. DR. JACKSON, MISSISSIPPI		CKD. 15
ELEVATIONS, SECTION, DOOR & FRAME SCHEDULE		REV. 11/5

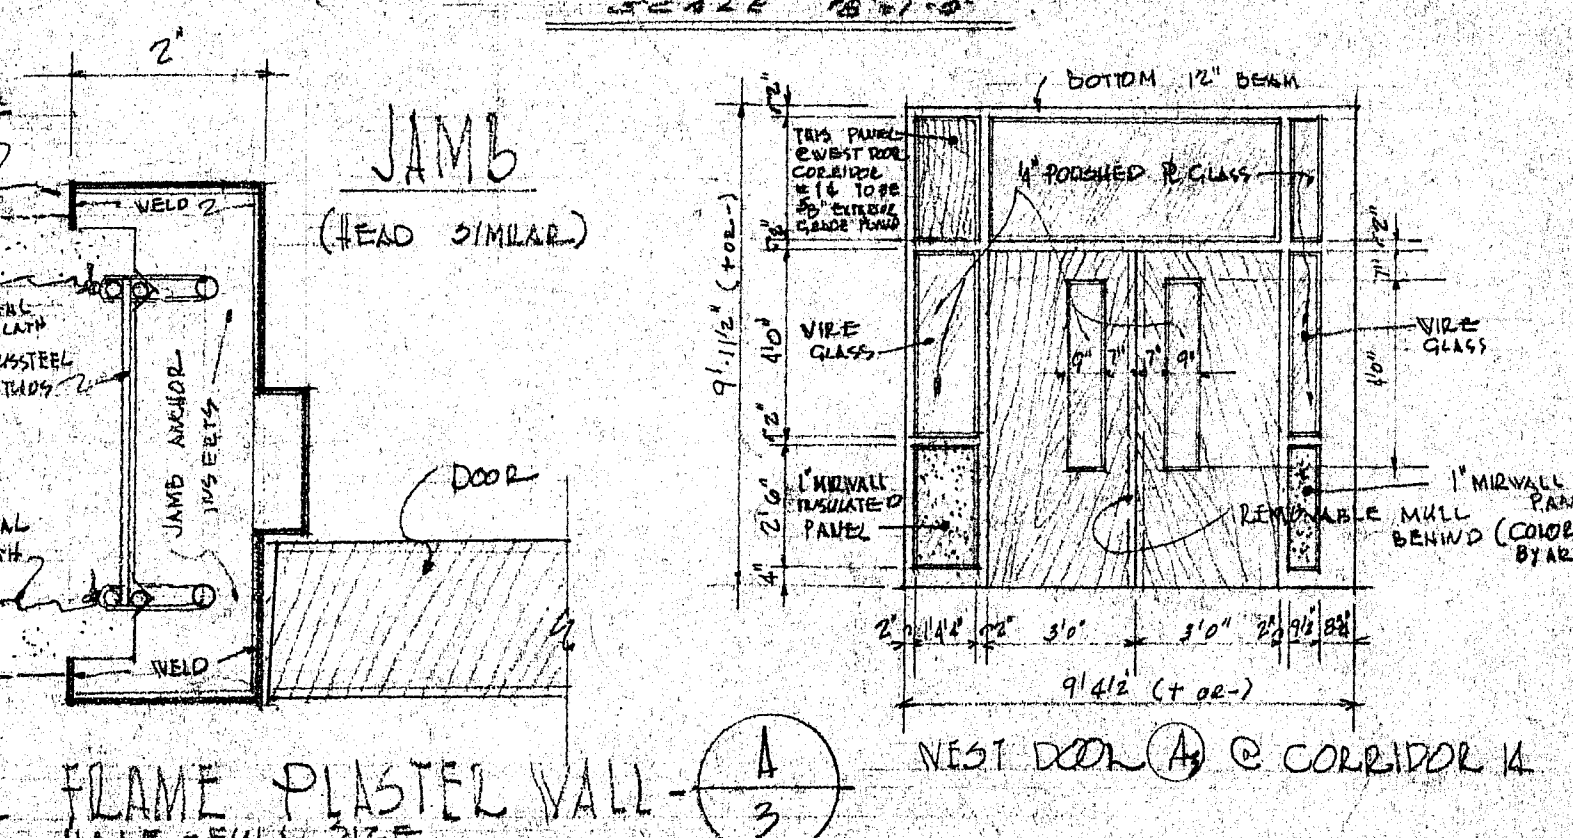

METAL FRAME PLASTER WALL - SCALE HALF-FULL SIZE

NAME OF SCHOOL

MAYOR
CITY COMMISSION
MEMBERS, BOARD OF TRUSTEES

ARCHITECT
ELECTRICAL ENGR.
MECHANICAL ENGR.
STRUCTURAL ENGR.

GENERAL CONTRACTOR
PLUMBING CONTRACTOR
ELECTRICAL CONTRACTOR

JOB SIGN

THIS CONTRACTOR TO FURNISH AND ERECT
WERE DIRECTED BY THE ARCHITECT. A
10'x80' SIGN, MOUNTED ON 4"x4" POST
ANCHORED SECURELY IN THE GROUND.
SUBMIT SHOP DRAWING.



A-FLUSH MOUNTED STANDING
FULL HEIGHT SPEC. R WITH
6-3/4" SHIRT BRACKET FOR
10" SLEEVES EA. UNIT.
R 8" V. APPROVAL EQUIV.

ELEVATION SCALE 3/8"=1'-0"

DISPLAY CASE PLAN - SCALE 3/8"=1'-0"

FLOOR PLAN
SCALE 1/8"=1'-0"

NOTE: CONTRACTOR SHALL VERIFY ALL DIMENSIONS ON THE PROJECT	
ALTERATIONS & ADDITIONS TO MURRAY ELEMENTARY SCHOOL 2909 OAK FOREST DRIVE, JACKSON, MISS.	COMM. NO. 2322
BURTON & STAATS A.I.A. ARCHITECTS & CONSULTING DESIGNERS 4503 OFFICE PARK, JACKSON, MISSISSIPPI	DATE 5/1/66
FLOOR PLAN	DRN. SMB
	CKD. JS
	REV.
	A2

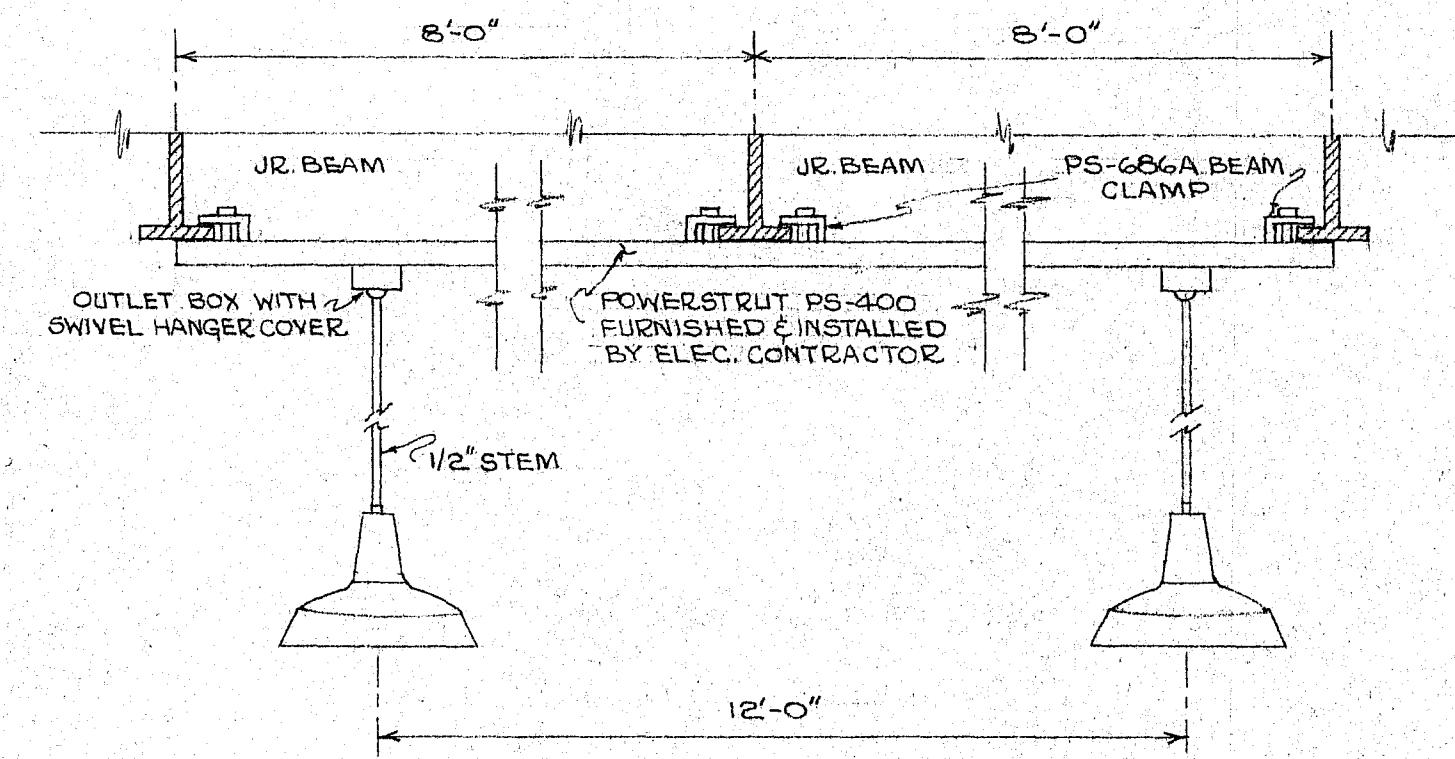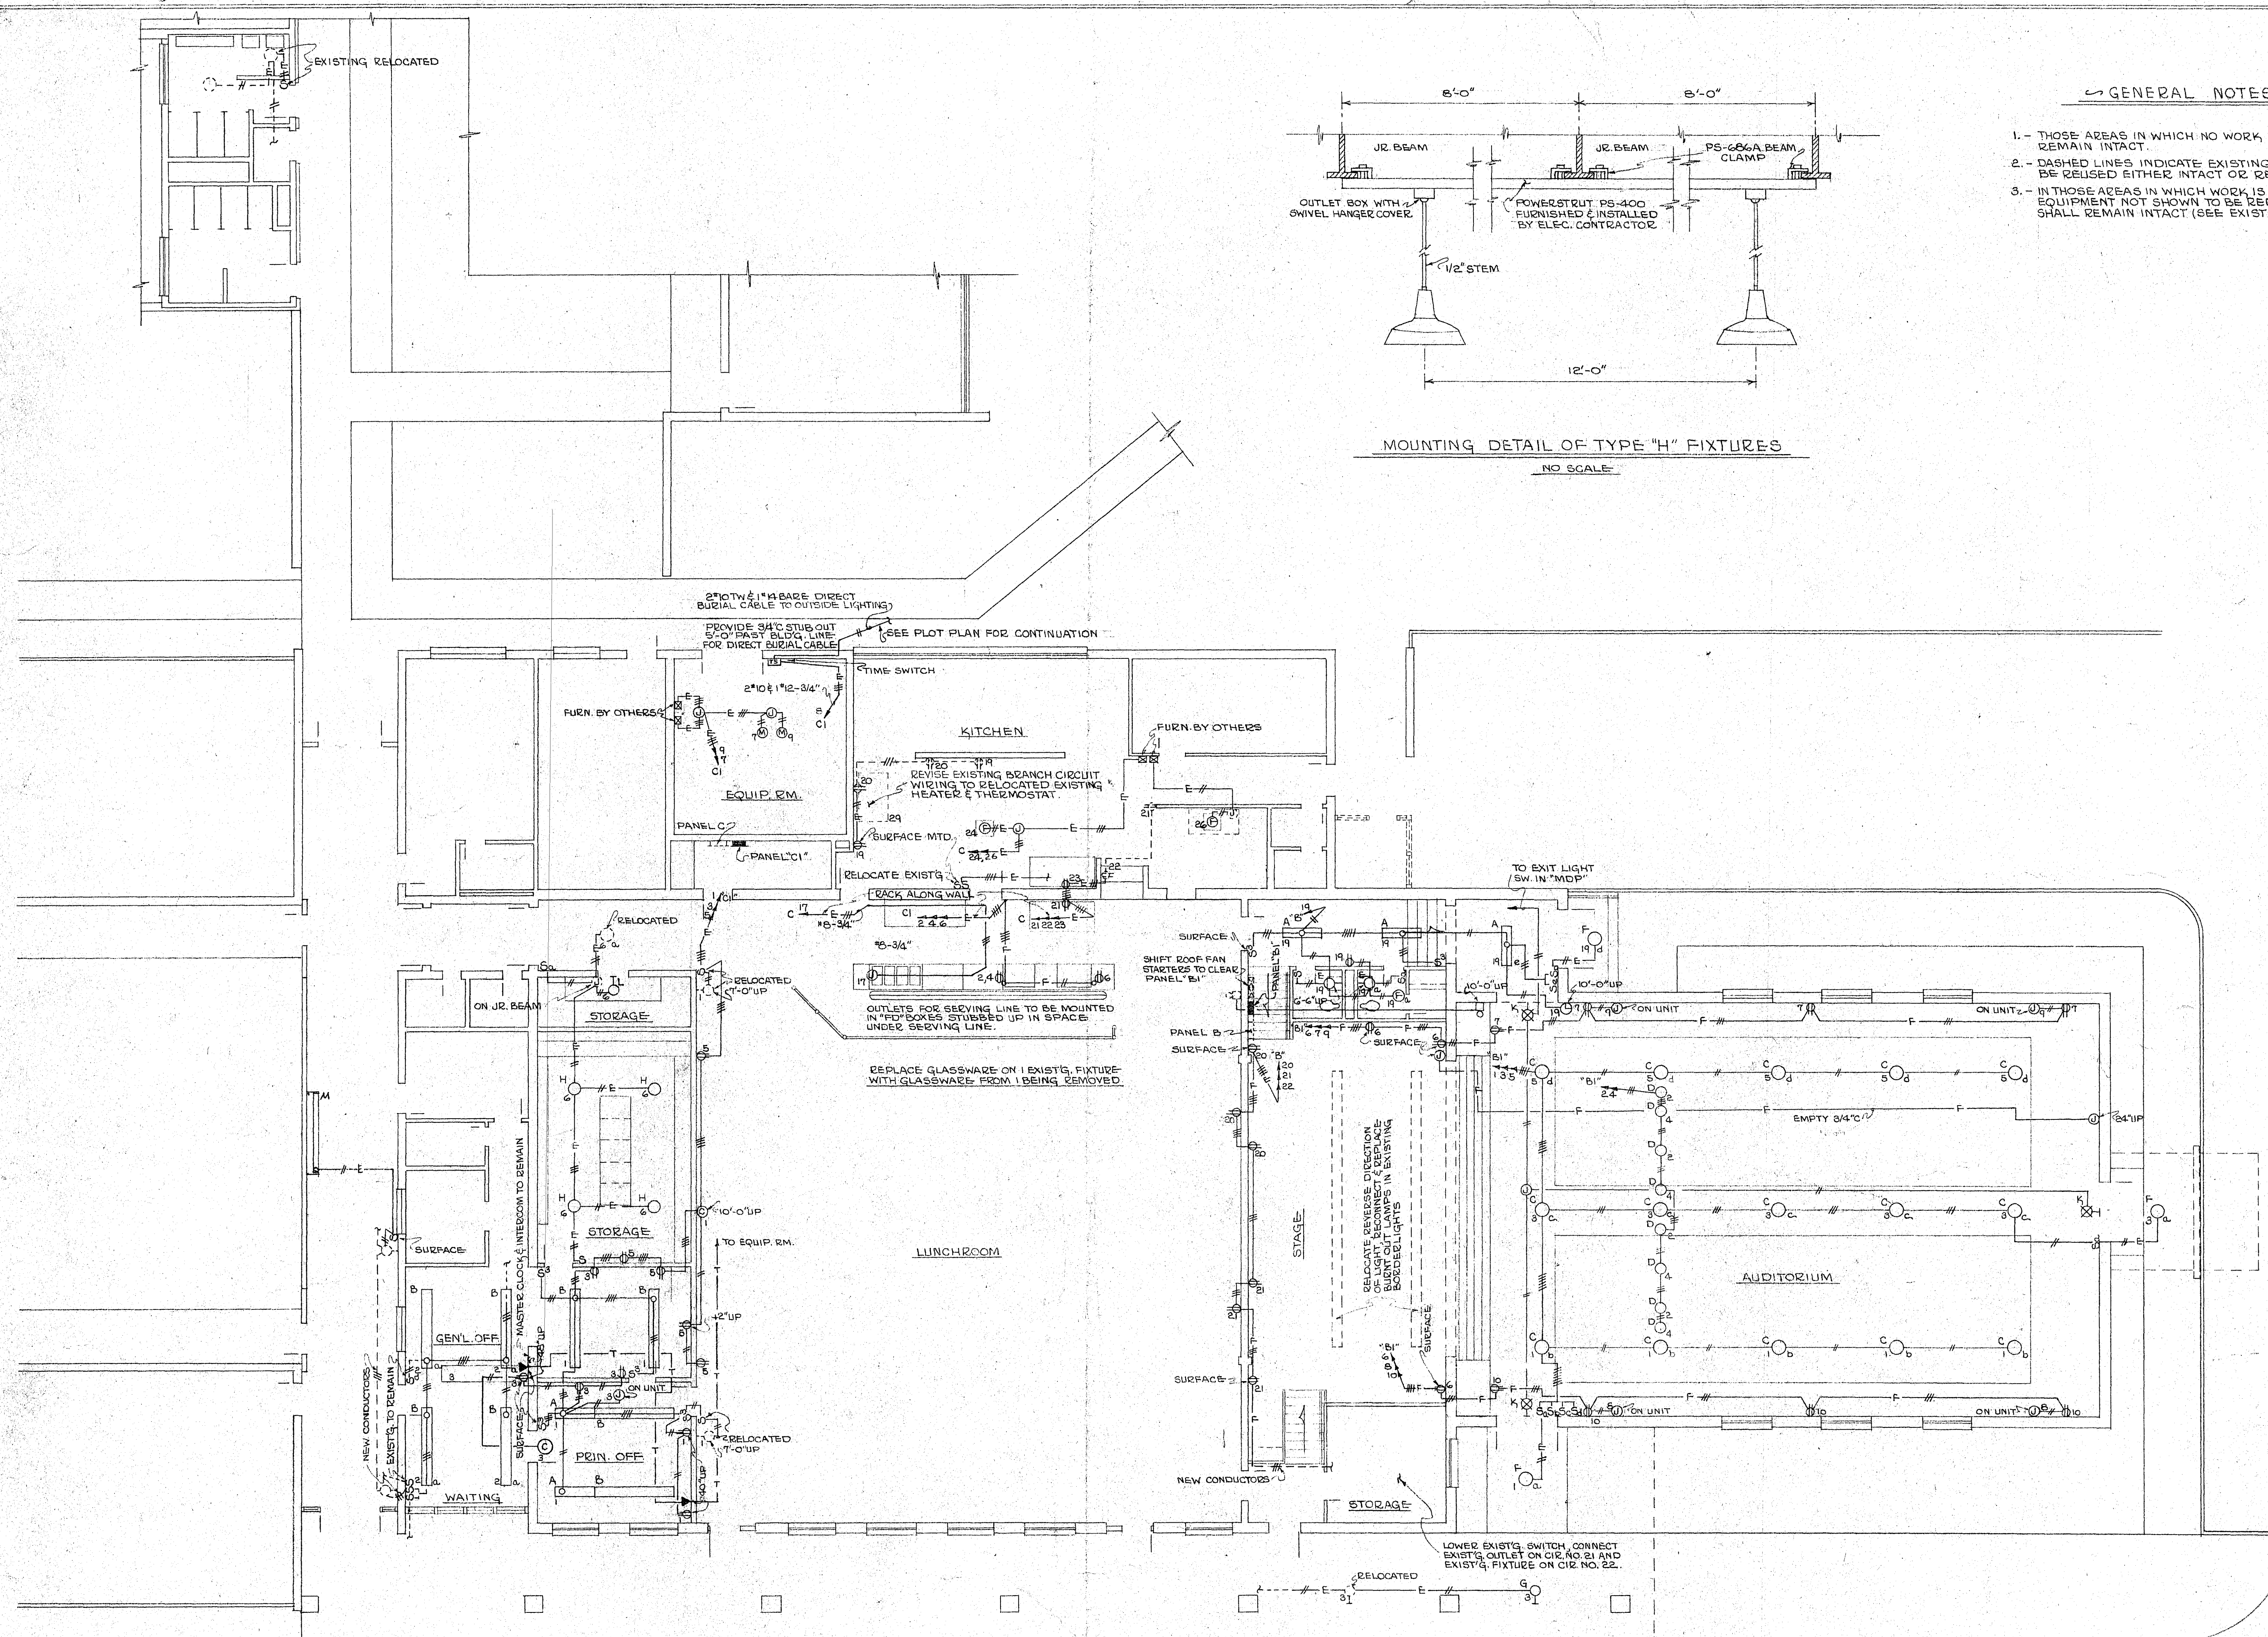


MOUNTING DETAIL OF TYPE "H" FIXTURES
NO SCALE

GENERAL NOTES

1. - THOSE AREAS IN WHICH NO WORK IS SHOWN ARE TO REMAIN INTACT.
2. - DASHED LINES INDICATE EXISTING EQUIPMENT TO BE REUSED EITHER INTACT OR RELOCATED.
3. - IN THOSE AREAS IN WHICH WORK IS SHOWN EXISTING EQUIPMENT NOT SHOWN TO BE REMOVED OR RELOCATED SHALL REMAIN INTACT (SEE EXIST'G. WIRING PLAN).

FLOOR PLAN
SCALE: 1/8"=1'-0"

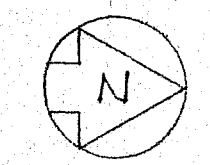

AS-BUILT 5/11/65 RFB


NOTE: CONTRACTOR SHALL VERIFY ALL DIMENSIONS ON THE PROJECT

ALTERATIONS & ADDITIONS TO
MARSHALL ELEMENTARY SCHOOL
2909 OAK FOREST DRIVE, JACKSON, MISS.
DATE: 5/11/64

BURTON & STAATS A.L.A.
ARCHITECTS & CONSULTING DESIGNERS
4503 OFFICE PARK DR., JACKSON, MISSISSIPPI
ELECTRICAL PLAN
E1 of 3

TYPICAL PANELBOARD LAYOUTS

Phase position, wire color code, circuit numbering.

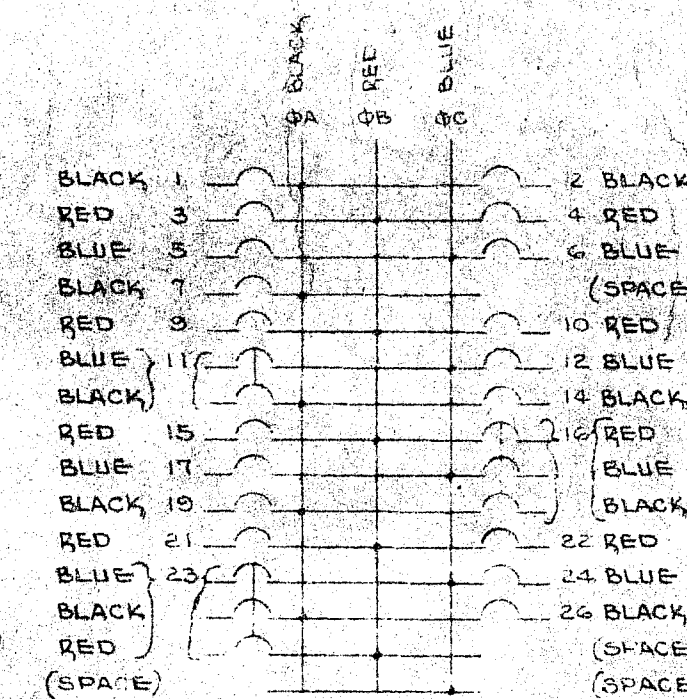

THREE PHASE, FOUR WIRE, WYE





INSTALL I-T-E CIRCUIT BRKR.
CO. 50A-3P "E FRAME" BRKR
IN SPACE NO. 37.

REPLACE BRANCH BRKRS
NOS 98-130 WITH J-T-E
CIRCUIT BRKR. CO. 50A-3P
TYPE "EQ" BREAKER.

RISER DIAGRAM

NO SCALE

PANELBOARD SCHEDULE							
PANEL	MOUNTING	MAINS		20A-1P	20A-2P	UNUSED NOS	REMARKS
B1	SURFACE	WGS ONLY	IN USE- SPACE	1-10 11-14			FED BY 50A-5P BRKR. NO. 25 IN PANEL B.
C1	SURFACE	WGS ONLY	IN USE- SPACE	1-7 & 9 11-16	8	10	FED BY 50A-3P BRKR. NO. 37 IN PANEL C. CONTAINS FOUR 1P SPACES

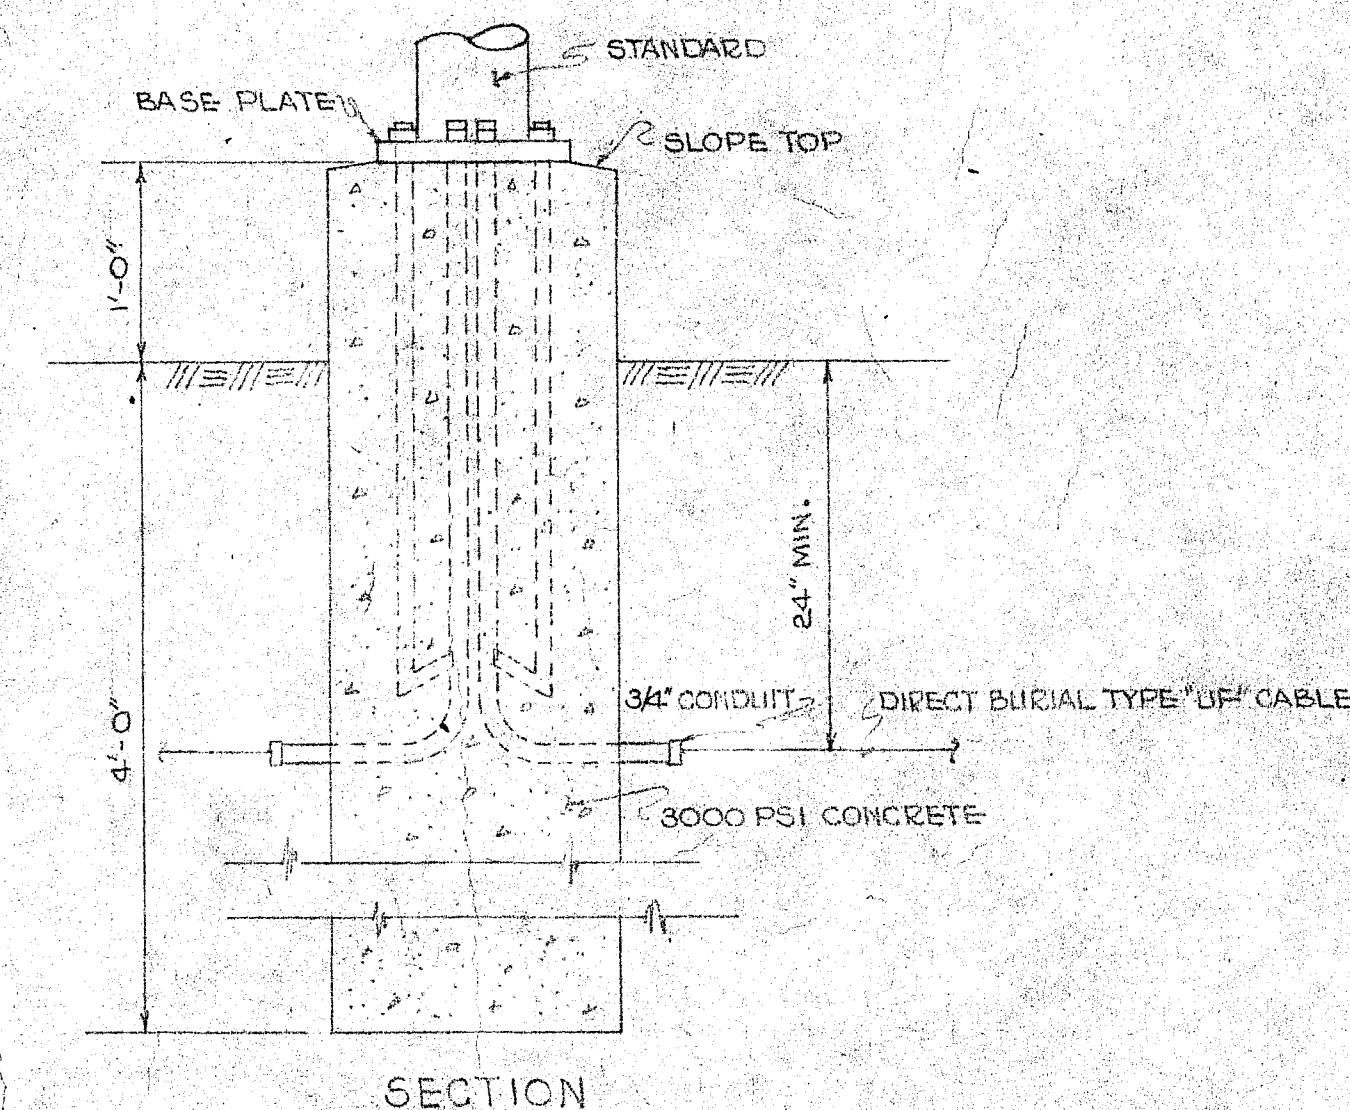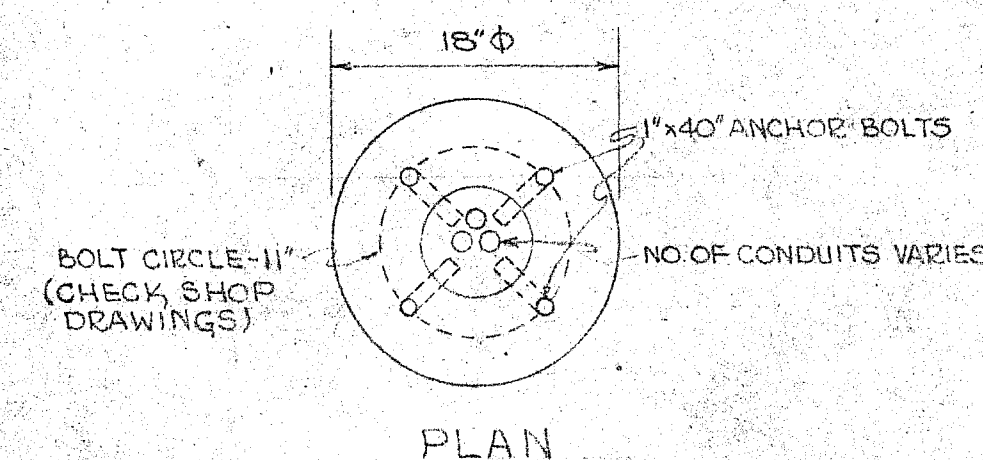

DETAIL OF CONCRETE BASE
FOR LIGHTING STANDARD

NO SCALE

AS-BUILT 5/11/65 REB

NOTE: CONTRACTOR SHALL VERIFY ALL DIMENSIONS ON THE FIELD.

11/11/1964

41/1000 203 4 ADDITIONAL 10

UNION HALL ELEMENTARY SCHOOL
2909 OAK FOREST DRIVE, CHICAGO, ILL.

BURTON 8 054430 DRN

BURTON & STAATS A.L.A.
ARCHITECTS & CONSULTING DESIGNERS

4523 STEPHEN AVE. JACKSON, MISSISSIPPI

JACKSON, MISSISSIPPI


EXISTING WIRING & ELECTRICAL
DETAILS.

RENOVATIONS SUMMER 2011


MARSHALL ELEMENTARY SCHOOL
DATE: 6/28/11
NEW CEILING/FLUORESCENT LIGHTING LEGEND:

☒ NEW (TYPICAL) 2' X 4' FLUORESCENT LIGHTING FIXTURES IN NEW CEILING/GRID (CEILING HEIGHT BY JPS CARPENTRY SUPERVISOR ALL NEW AREAS) JPS ELECTRICAL DEPT. CONNECT TO EXISTING CIRCUITS/SWITCH (S). LAYOUT SHOWN IS TYPICAL FOR IDEAL FIELD CONDITIONS. ELECTRICAL DEPT. MAY FIND IT NECESSARY TO MOVE LIGHTING TO NEXT ADJACENT TILE TO RESOLVE CONFLICTS WITH EXISTING BUILDING CONDITIONS (PIPING, DUCTS, FURRINGS, ETC.) ANGLE NEW TILE TO EXISTING HVAC DUCTS AT CEILING REFERENCE ANY QUESTIONS TO JPS ELECTRICAL DEPT. SUPERVISOR, MR. HOLLIS. REFERENCE WRITTEN SPECIFICATIONS FOR CEILING/GRID TYPE AND COLOR AND OTHER INSTRUCTIONS.


Ⓜ PROVIDE CORRIDOR HEAT RADANT PANEL (S) IN NEW CEILING

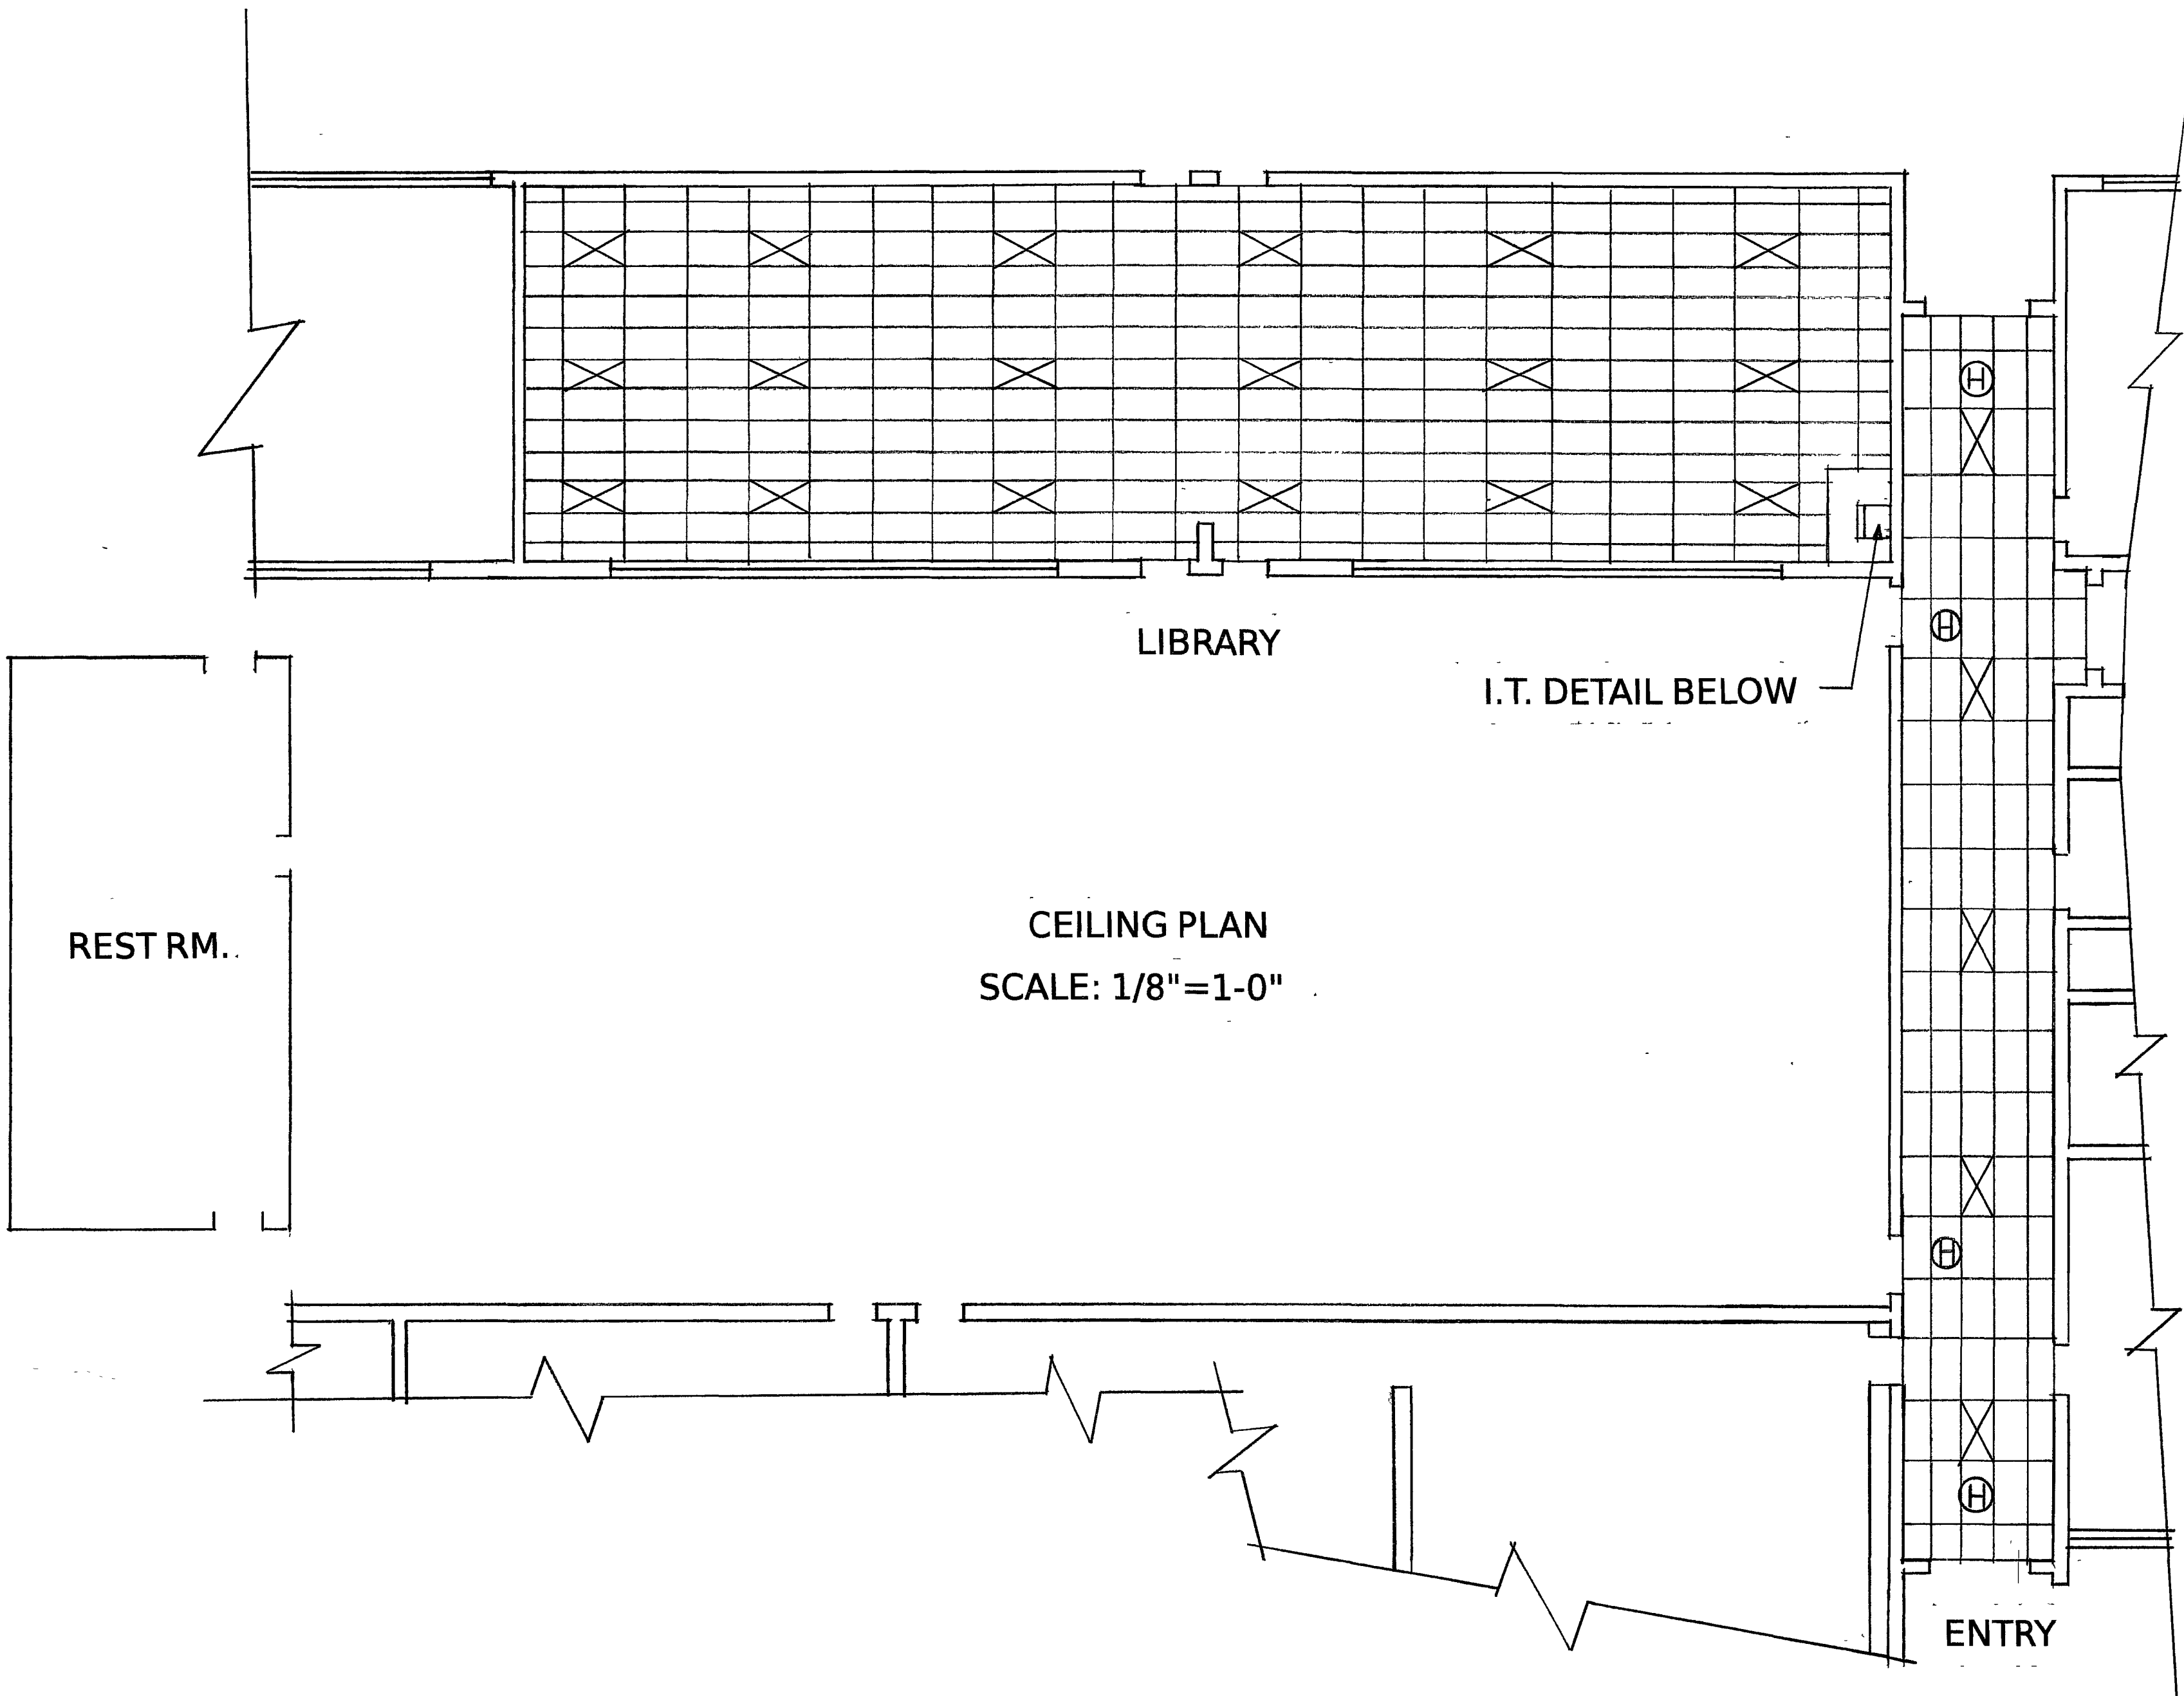

- MARSHALL ELEMENTARY SCHOOL
NEW CEILING/LIGHTING
GENERAL CONSTRUCTION NOTES
DATE: 6/28/11
1. NEW 2'X4' CEILING COLOR AND TYPE PER JPS WRITTEN SPECIFICATIONS AS SHOWN ON PLANS.
 2. NEW CEILING HEIGHT ALL AREAS PER JPS CARPENTRY SUPERVISOR.
 3. SECURITY DEVICES/MOTION SENSORS SHALL BE RELOCATED BY JPS SECURITY.
 4. WINDOWS IN CORRIDORS SHALL HAVE NEW CEILING TILE VERTICAL AND ATTACHED TO BLOCK VIEW INTO NEW CEILING VOID (VIEW FROM CLASSROOM AND BUILDING EXTERIOR).
 5. DATA WIRELESS CONTROLS SHALL BE RELOCATED BY JPS I. T. DEPARTMENT. REFERENCE MR. ALLEN JENKINS, I. T. DEPARTMENT.
 6. ALL QUESTIONS THIS PROJECT SHALL BE DIRECTED TO JPS CARPENTRY SUPERVISOR.
 7. ANY DEVICES/ITEMS NOT ADDRESSED IN THE ABOVE NOTES SHALL BE REPORTED TO JPS CARPENTRY SUPERVISOR WHERE THE NEW CEILING INTERSECTS OR SEALS OFF THE DEVICES/ITEMS, SO THAT THE CONFLICT CAN BE RESOLVED.
 8. PROVIDE ALL NEW EXHAUST FANS (2) SETS OF GANG TOILETS.

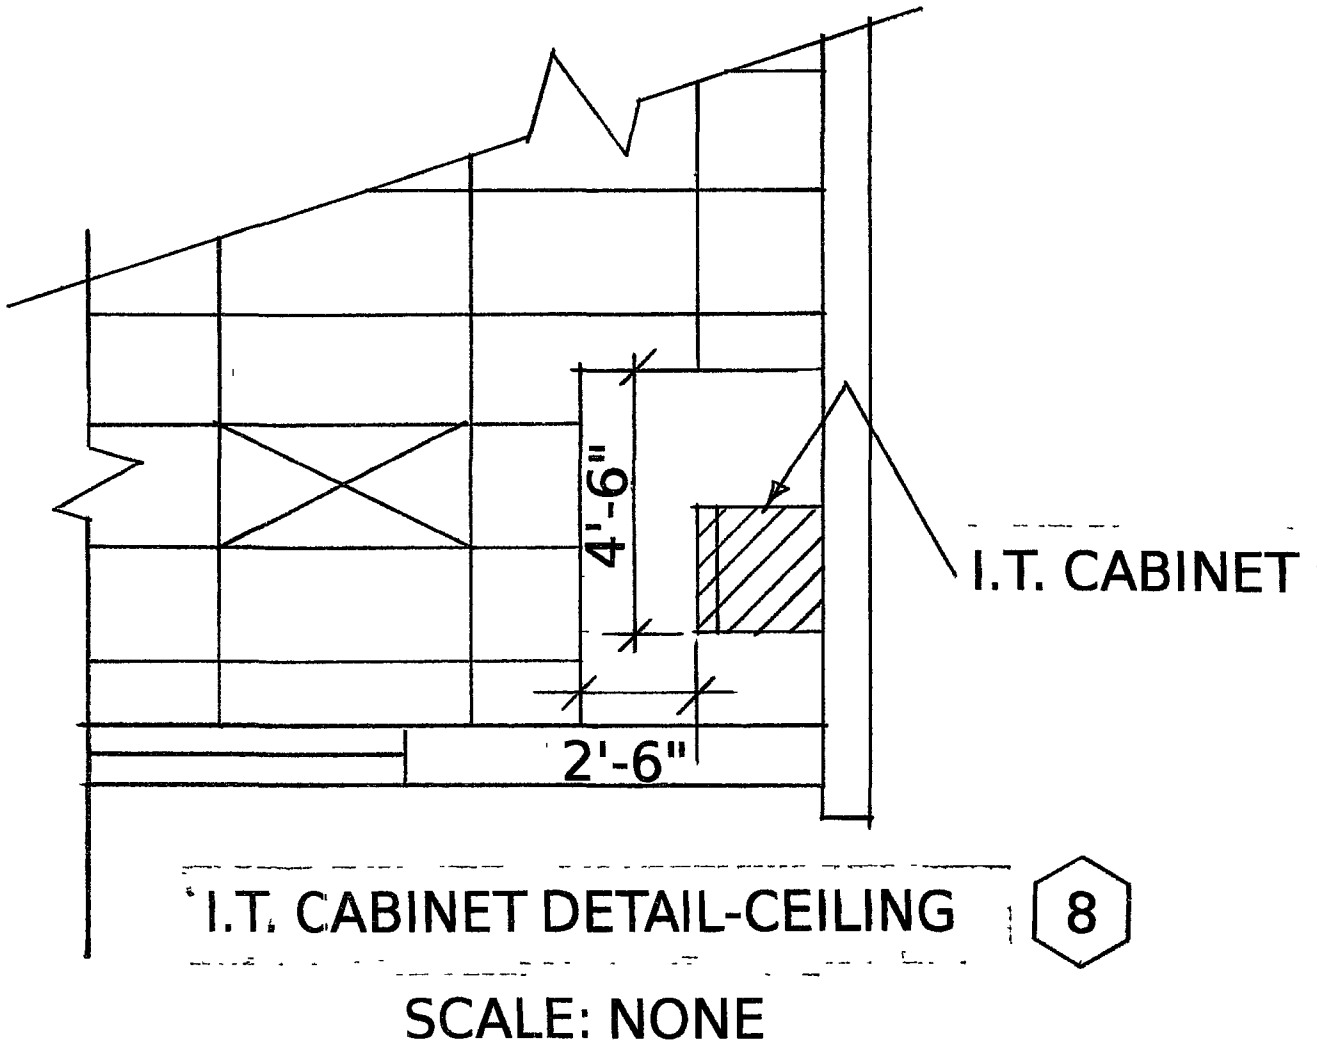

REVISIONS	
REVISED:	DATE:
FINAL	
APPROVED:	DATE: 7/25/11
DRAWN BY: WM	DATE: 6.30.11
VERIFY ALL DIMENSIONS	PRIOR TO CONSTRUCTION
JACKSON PUBLIC SCHOOL DISTRICT	
JACKSON, MISSISSIPPI	
SITE: MARSHALL ELEMENTARY SCHOOL	SITE ADDRESS: 2909 OAK FOREST DRIVE
CEILING PLAN	
SHEET: 1	OF: 3
DRAWING NUMBER	5017

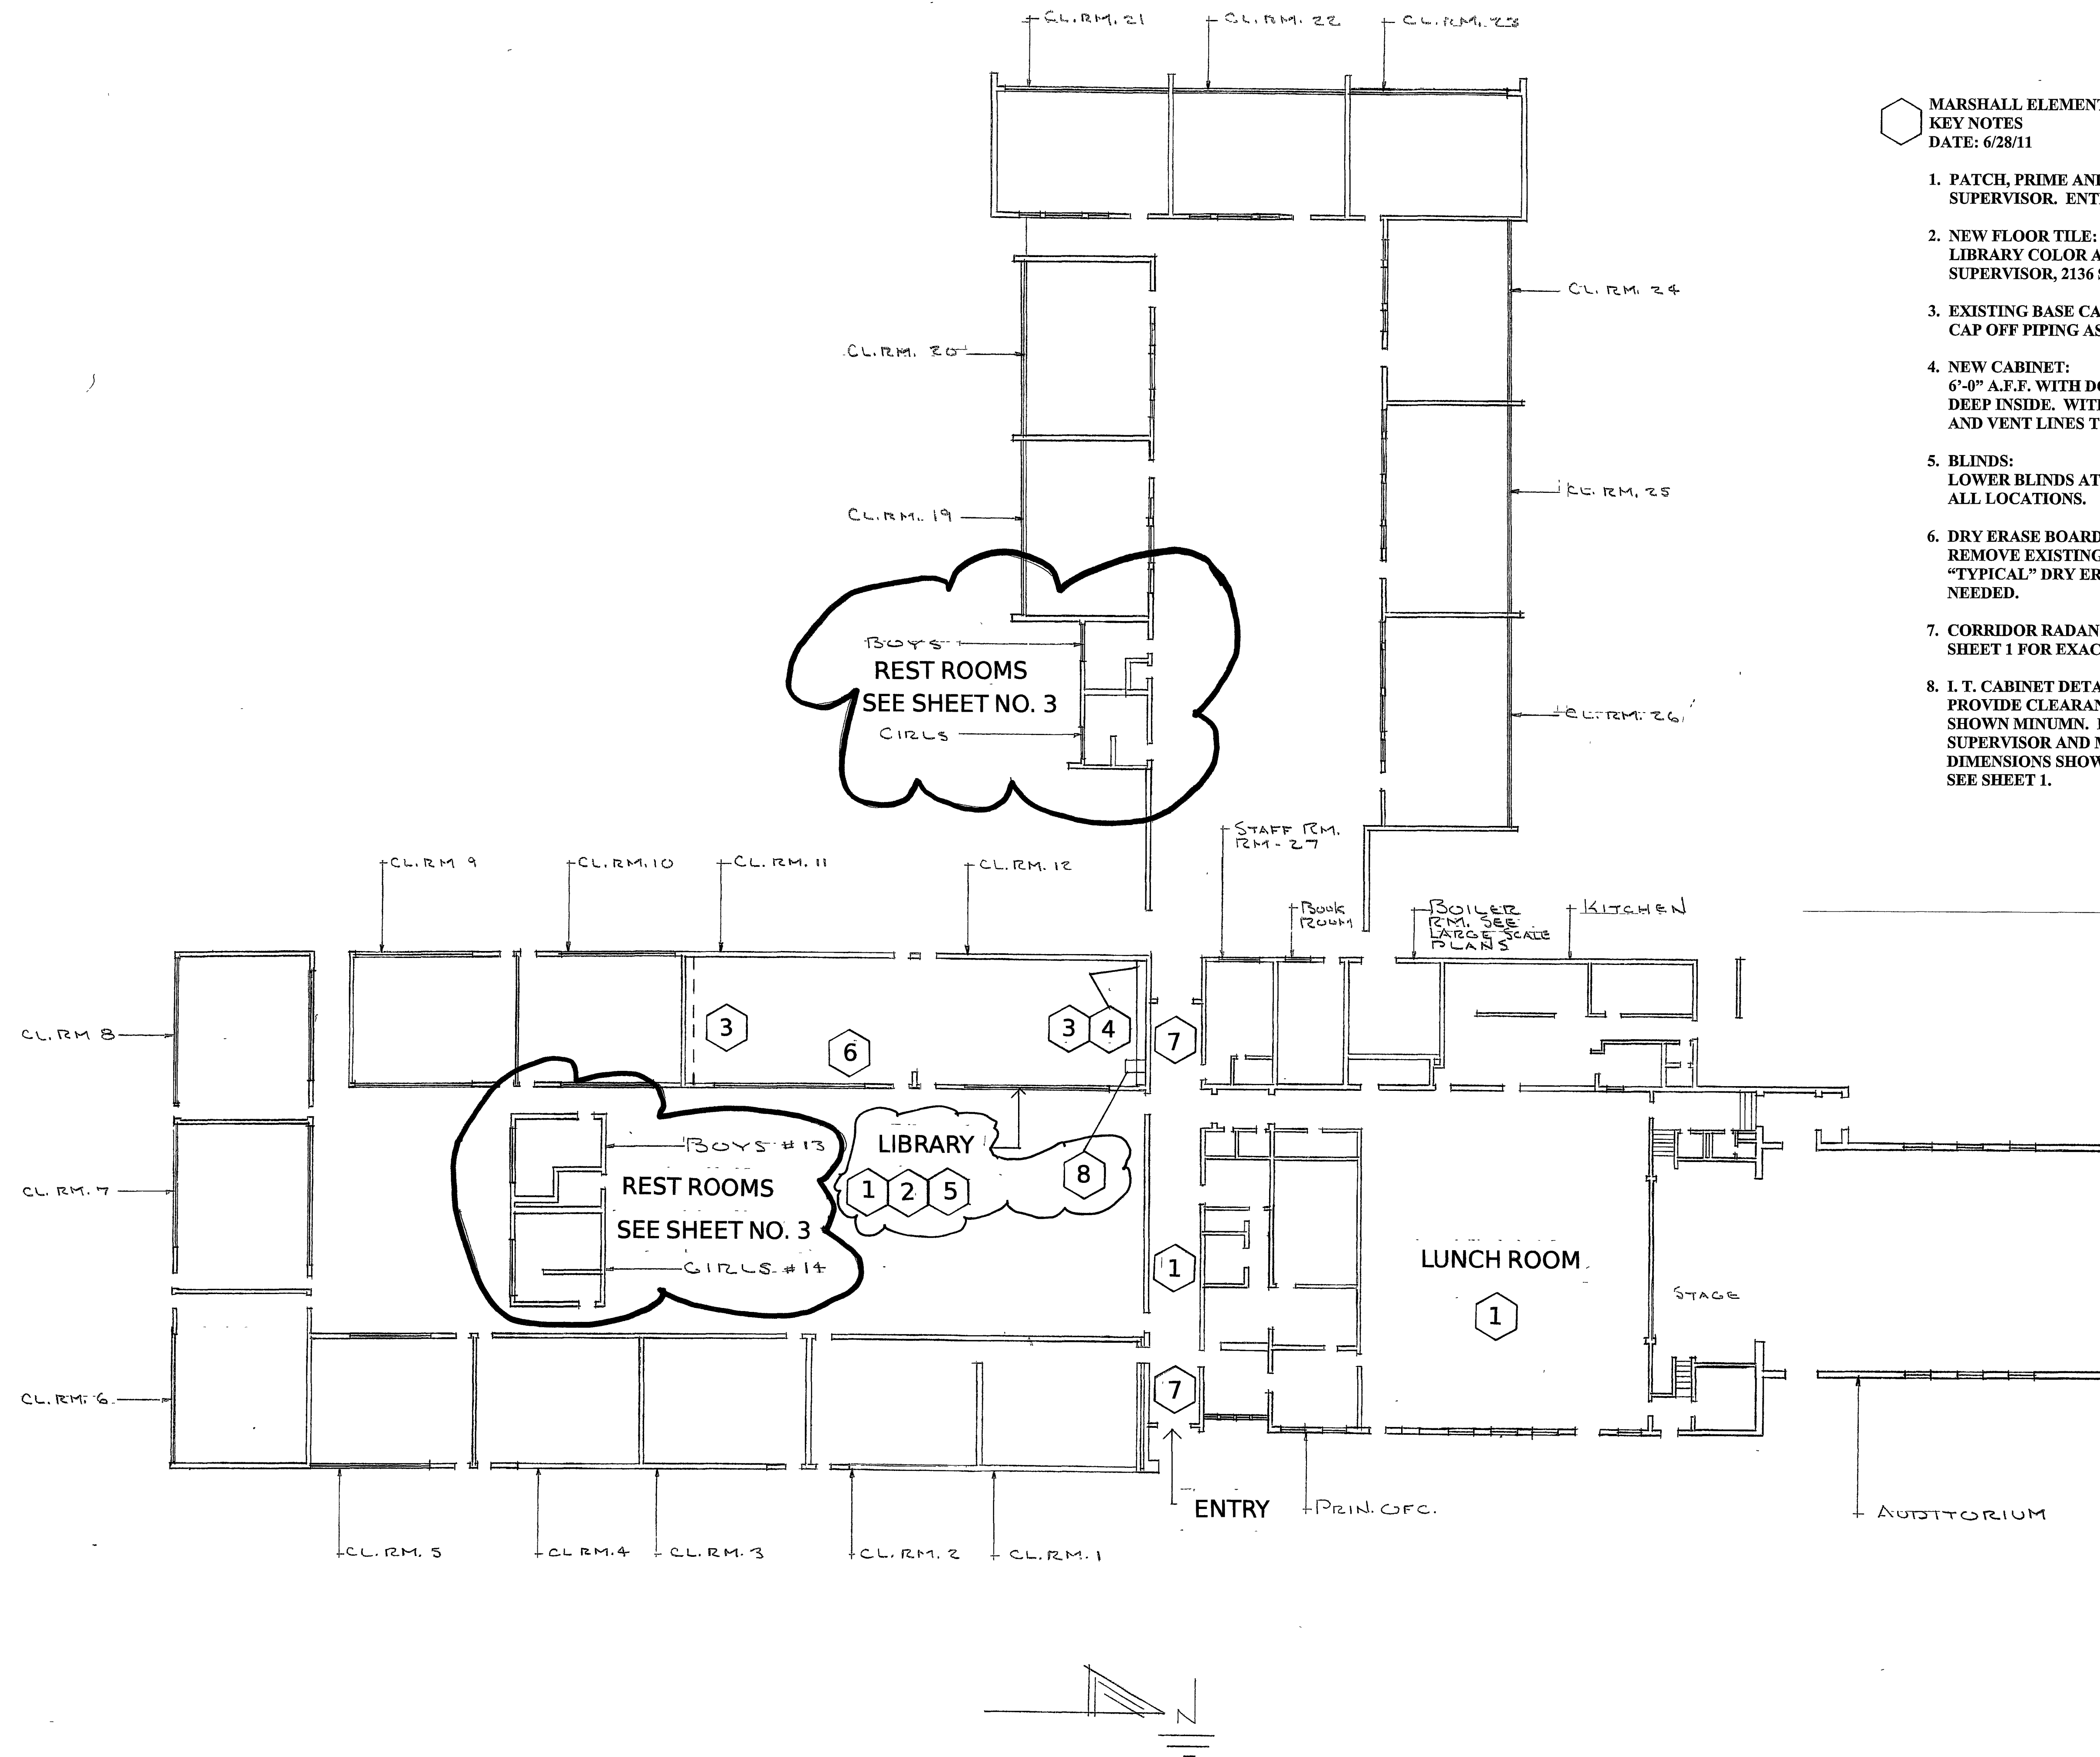

MARSHALL ELEMENTARY SCHOOL KEY NOTES DATE: 6/28/11

1. PATCH, PRIME AND PAINT COLOR BY CARPENTRY SUPERVISOR. ENTRY CORRIDOR, CAFETERIA, LIBRARY.
2. NEW FLOOR TILE:
LIBRARY COLOR AND TYPE BY J. P. S. CARPENTRY SUPERVISOR, 2136 SQ. FT. (VERIFY ON SITE SQ. FT.).
3. EXISTING BASE CABINET "REMOVAL" (2) LOCATIONS. CAP OFF PIPING AS NEEDED.
4. NEW CABINET:
6'-0" A.F.F. WITH DOORS ON FRONT AND SHELVES 16" DEEP INSIDE. WITH FURRING AROUND WATER SUPPLY AND VENT LINES TYPICAL.
5. BLINDS:
LOWER BLINDS AT WINDOWS BELOW NEW CEILING ALL LOCATIONS.
6. DRY ERASE BOARD (S)
REMOVE EXISTING CHALK BOARD (S) AND INSTALL "TYPICAL" DRY ERASE BOARDS, PATCH WALL IF NEEDED.
7. CORRIDOR RADANT HEAT PANEL AT CEILING SEE SHEET 1 FOR EXACT LOCATION.
8. I. T. CABINET DETAIL:
PROVIDE CLEARANCE AROUND I. T. CABINET AS SHOWN MINUM. FIELD VERIFY WITH CARPENTRY SUPERVISOR AND MR. ALLEN JENKINS, I. T. OFFICE, DIMENSIONS SHOWN FOR FRONT AND SIDE ACCESS. SEE SHEET 1.

JACKSON PUBLIC SCHOOL DISTRICT

JACKSON, MISSISSIPPI

SITE: MARSHALL ELEMENTARY SCHOOL

FLOOR PLAN-RENOVATIONS

SITE ADDRESS:

2909 OAK FOREST DRIVE

DRAWN BY: WM

DATE: 6.30.11

VERIFY ALL DIMENSIONS

PRIOR TO CONSTRUCTION

FINAL

APPROVED: *[Signature]*

DATE: 7/25/11

REVISED:


DATE:

SHEET: 2


OF: 3

DRAWING NUMBER 5018


FLOOR PLAN
SCALE: 1/16"=1'-0"

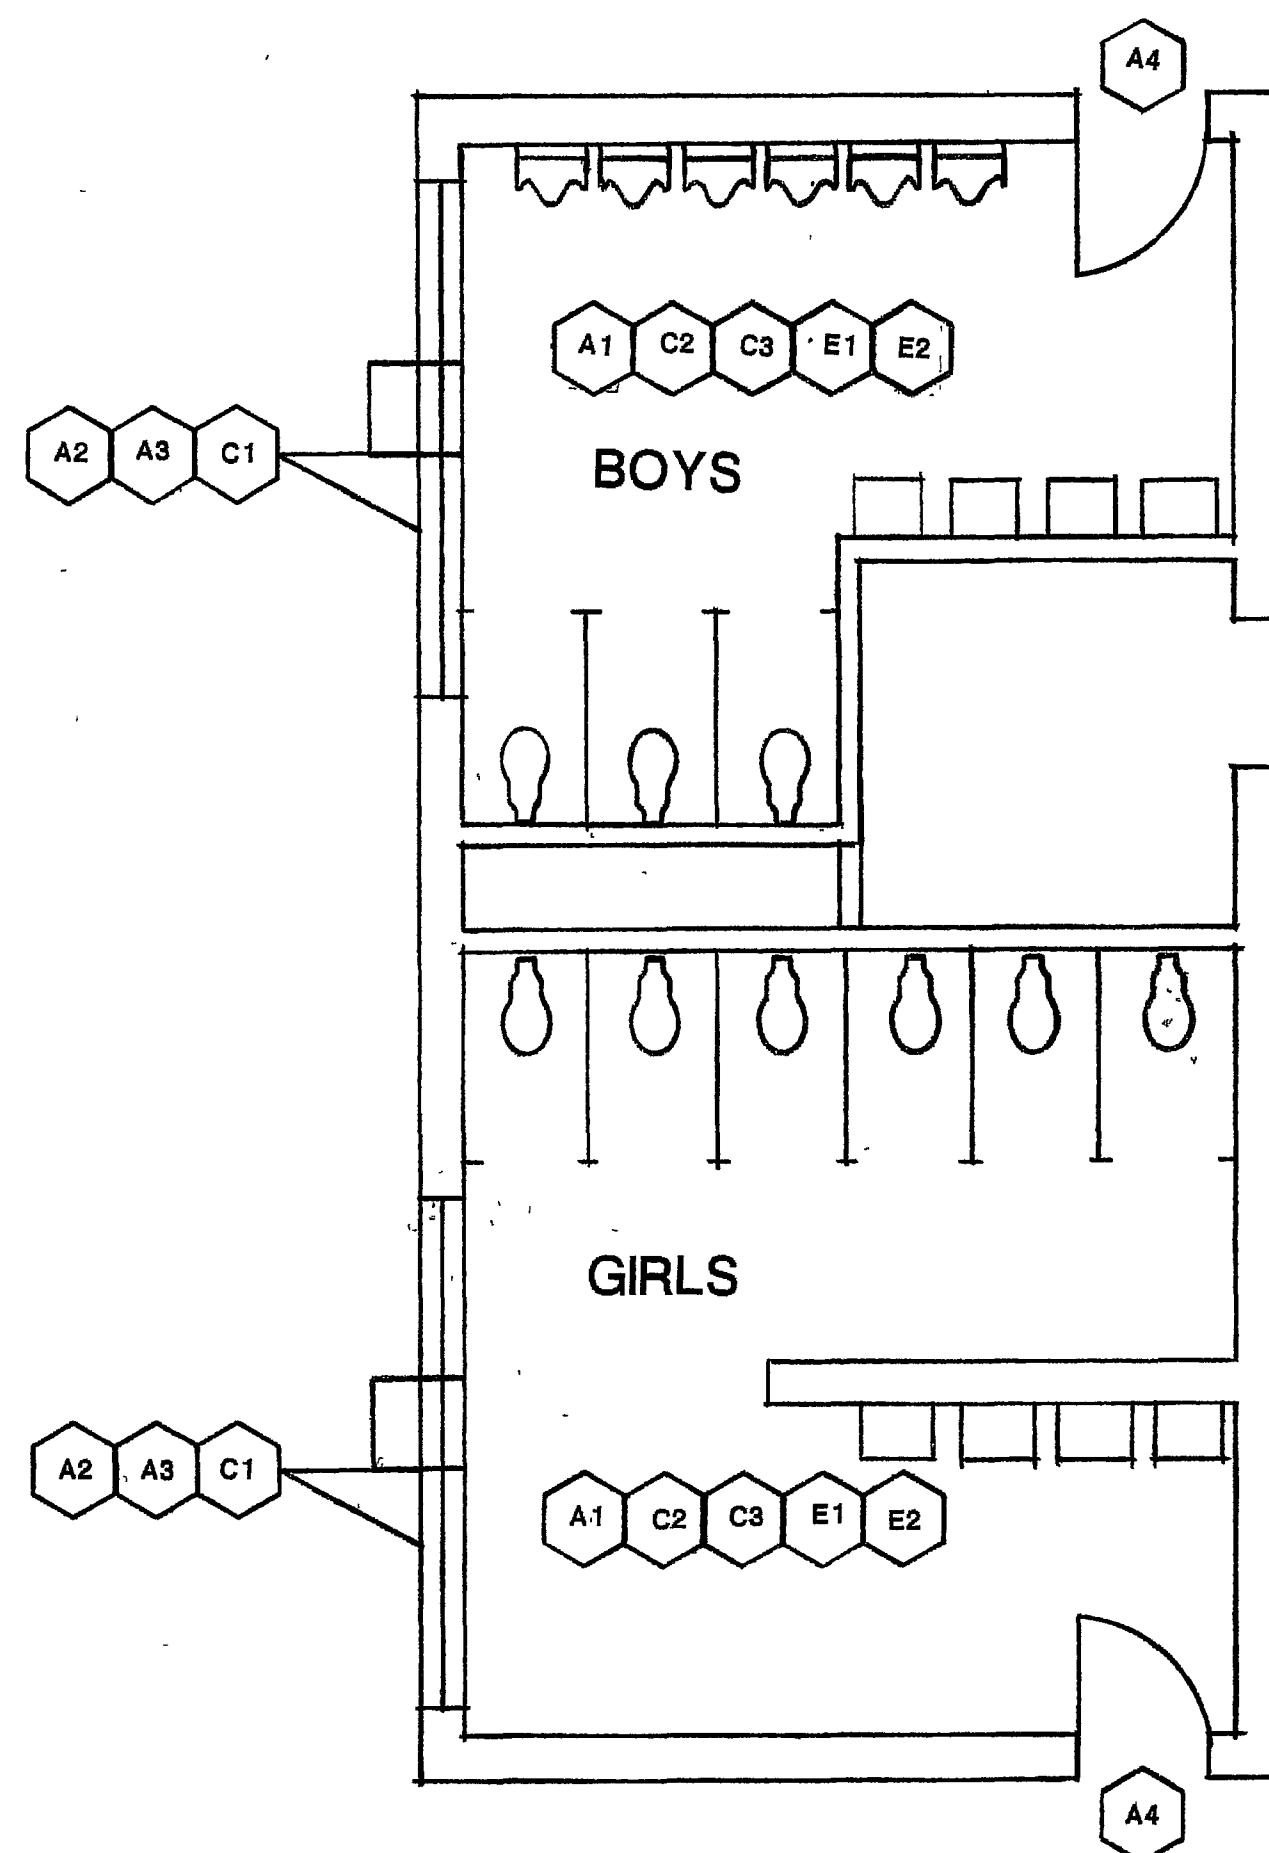

GANG TOILETS
SOUTH OF PRINCIPALS OFFICE

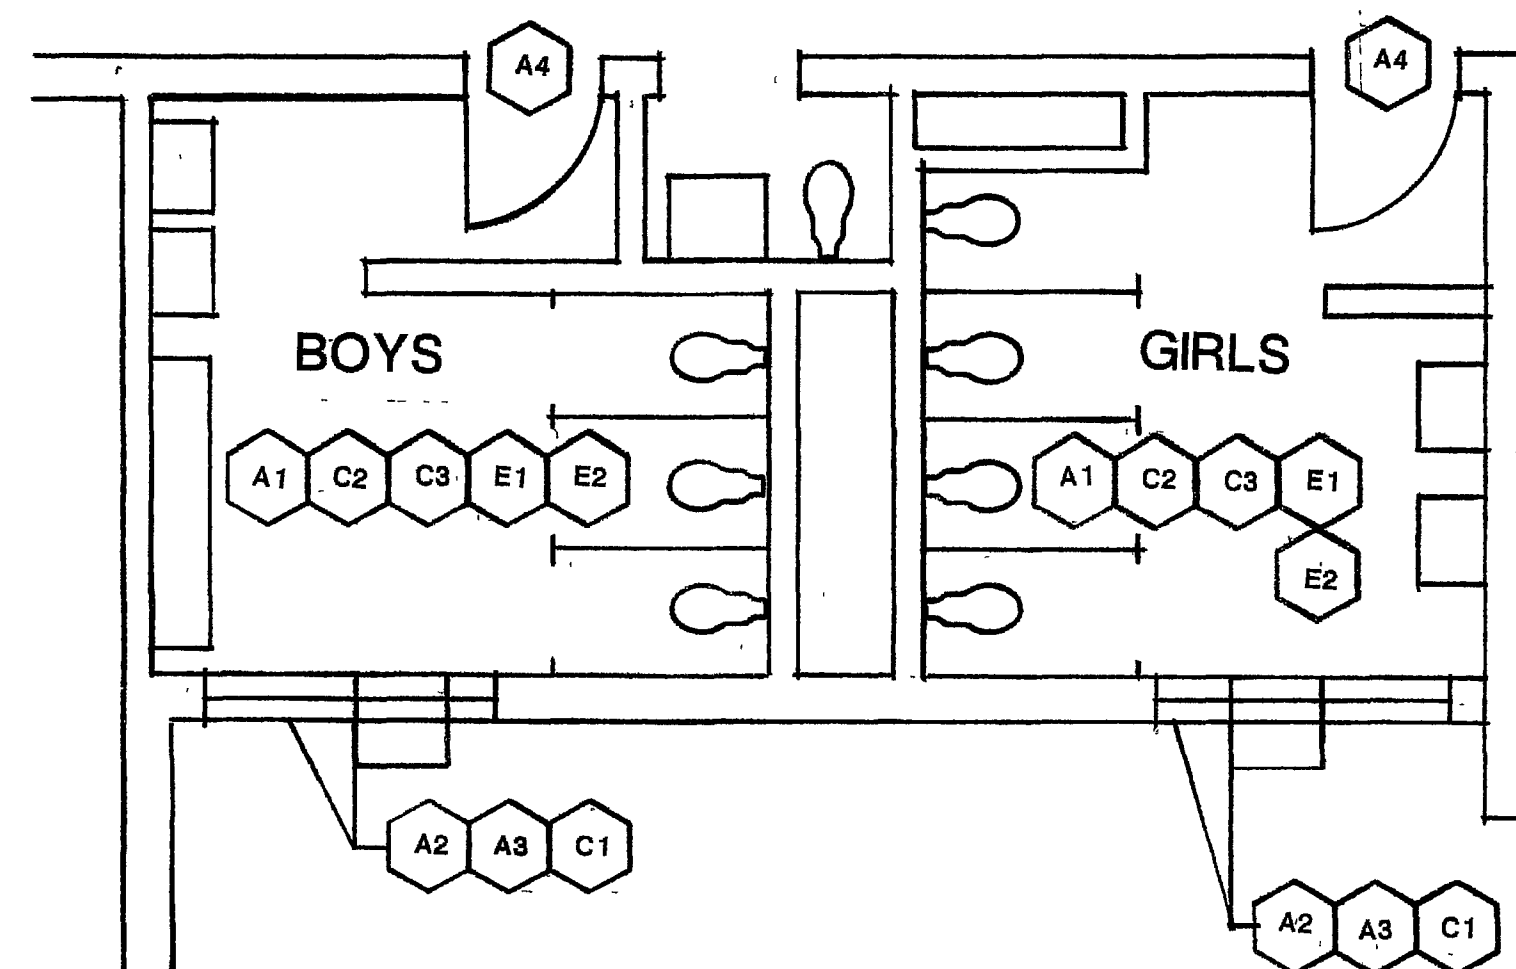

CEILING AND
FLOOR PLAN GANG TOILETS
SCALE: 1/4"=1'-0"

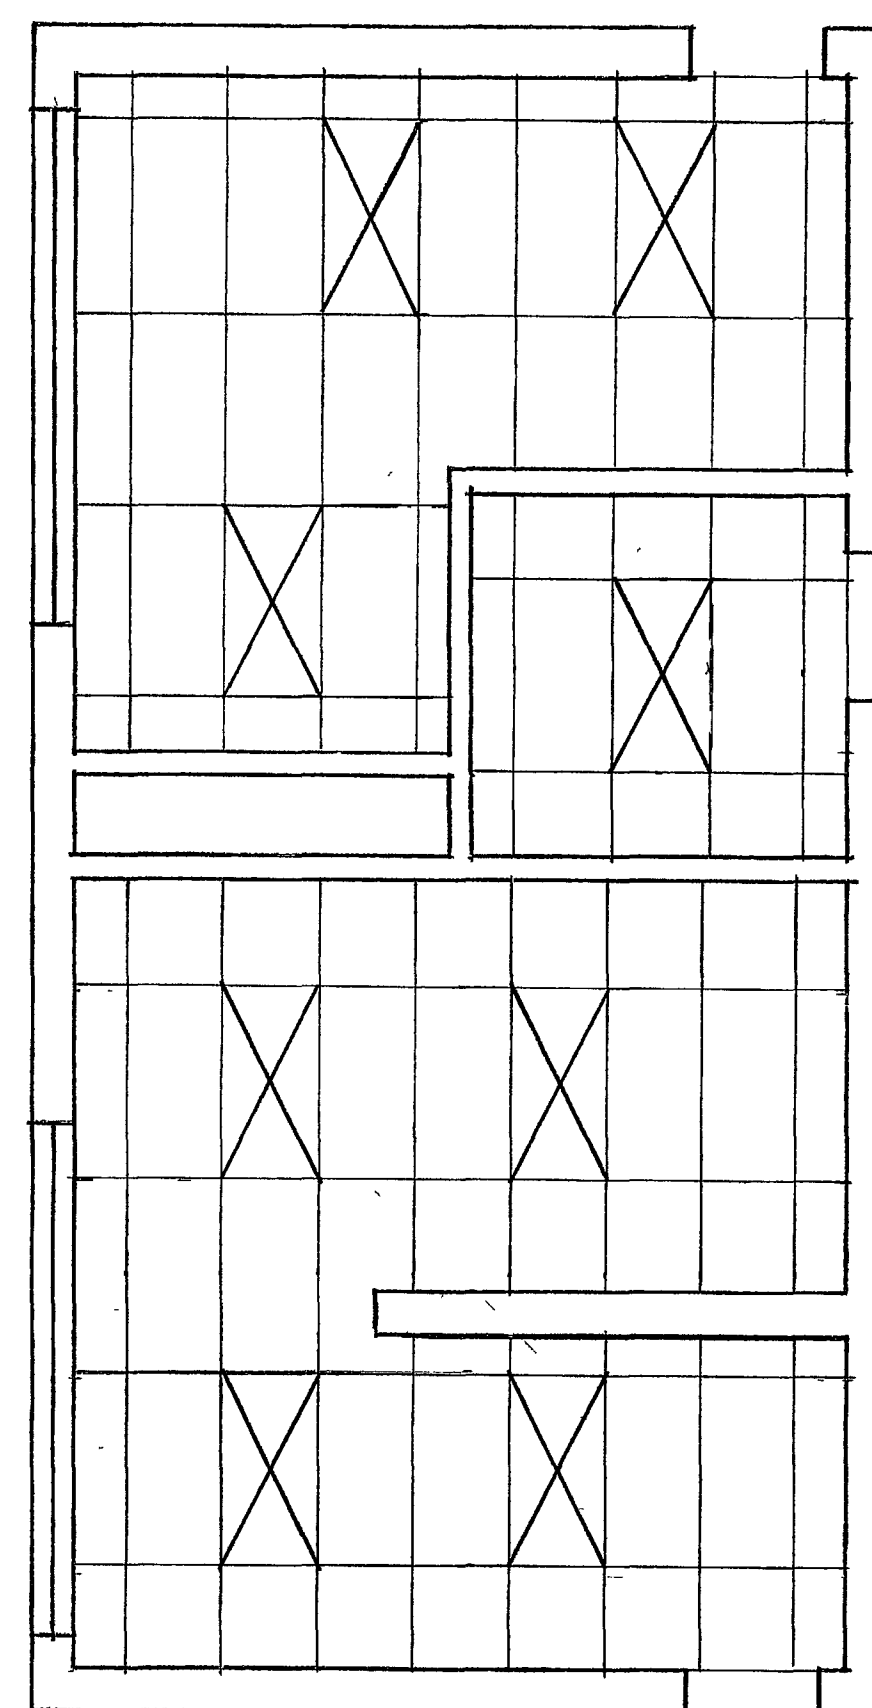

MARSHALL ELEMENTARY SCHOOL
RESTROOM RENOVATIONS
DATE: 6/30/11

CARPENTRY:

A1. NEW DROP CEILING HEIGHT BY CARPENTRY SUPERVISOR.

A2. BLANK PANEL ALL WINDOWS ABOVE CEILING HEIGHT.

A3. CUSTODIAL DEPT:
COMPLETELY CLEAN FLOOR BY SCRUBBING AND THOROUGHLY CLEAN ENTIRE RESTROOMS AFTER ALL CONSTRUCTION.

A4. EXTERIOR DOORS:
NEW VENTS NEW CLOSURE NEW SIGNAGE

CLIMATE CONTROL:

C1. EXHAUST FAN NO. 7A621 "GRAINGER" WITH CURB AT ROOF TYPICAL.

C2. REMOVE OR RE-HANG EXISTING GAS HEATERS.

C3. REFERENCE BONDED ROOF NOTE, THIS SHEET FOR FAN(S) ROOF CURBS AT ROOF.

ELECTRICAL:

E1. PROVIDE NEW FLUORESCENT LIGHTING FOR NEW DROP CEILING.

E2. PROVIDE ELECTRICAL SERVICE TO EXHAUST FANS AND MOTION SENSORS AT WALLS TYPICAL.


GENERAL NOTES:

1. VERIFY THAT ALL EXTERIOR DOORS FUNCTION PROPERLY.

2. VERIFY THAT ALL RESTROOM STALLS FUNCTION PROPERLY.

MARSHALL ELEMENTARY SCHOOL
ROOF WORK - ALL ROOF PENETRATIONS
BONDED ROOF - NEW EXHAUST FANS
DATE: 7-12-11

PRIOR TO CURB/EXHAUST FAN INSTALLATION, JPS STAFF SHALL CONTACT MR. BILL BASS (TREMO) AT 601-624-2595 TO OBTAIN APPROVAL AND LOCATE AN APPROVED ROOF CONTRACTOR. THIS FACILITY HAS A 20 YEARS SERVICE AGREEMENT/WARRANTY. THIS ROOF CONTRACTOR SHALL BE LICENSED, BONDED AND INSURED AND SHOW PROOF OF ALL (3) PRIOR TO ROOF WORK. THE CONTRACTOR SHALL ALSO BE RESPONSIBLE FOR ANY DAMAGE TO JPS PROPERTY OR THE SCHOOL BUILDING. THE CONTRACTOR SHALL LEAVE THE BUILDING/GROUNDS CLEAN AS BEFORE. THE NEW EXHAUST FANS, CURB AND ELECTRICAL SERVICE SHALL ALL FOLLOW EXHAUST FAN MANUFACTURES RECOMMENDATIONS.

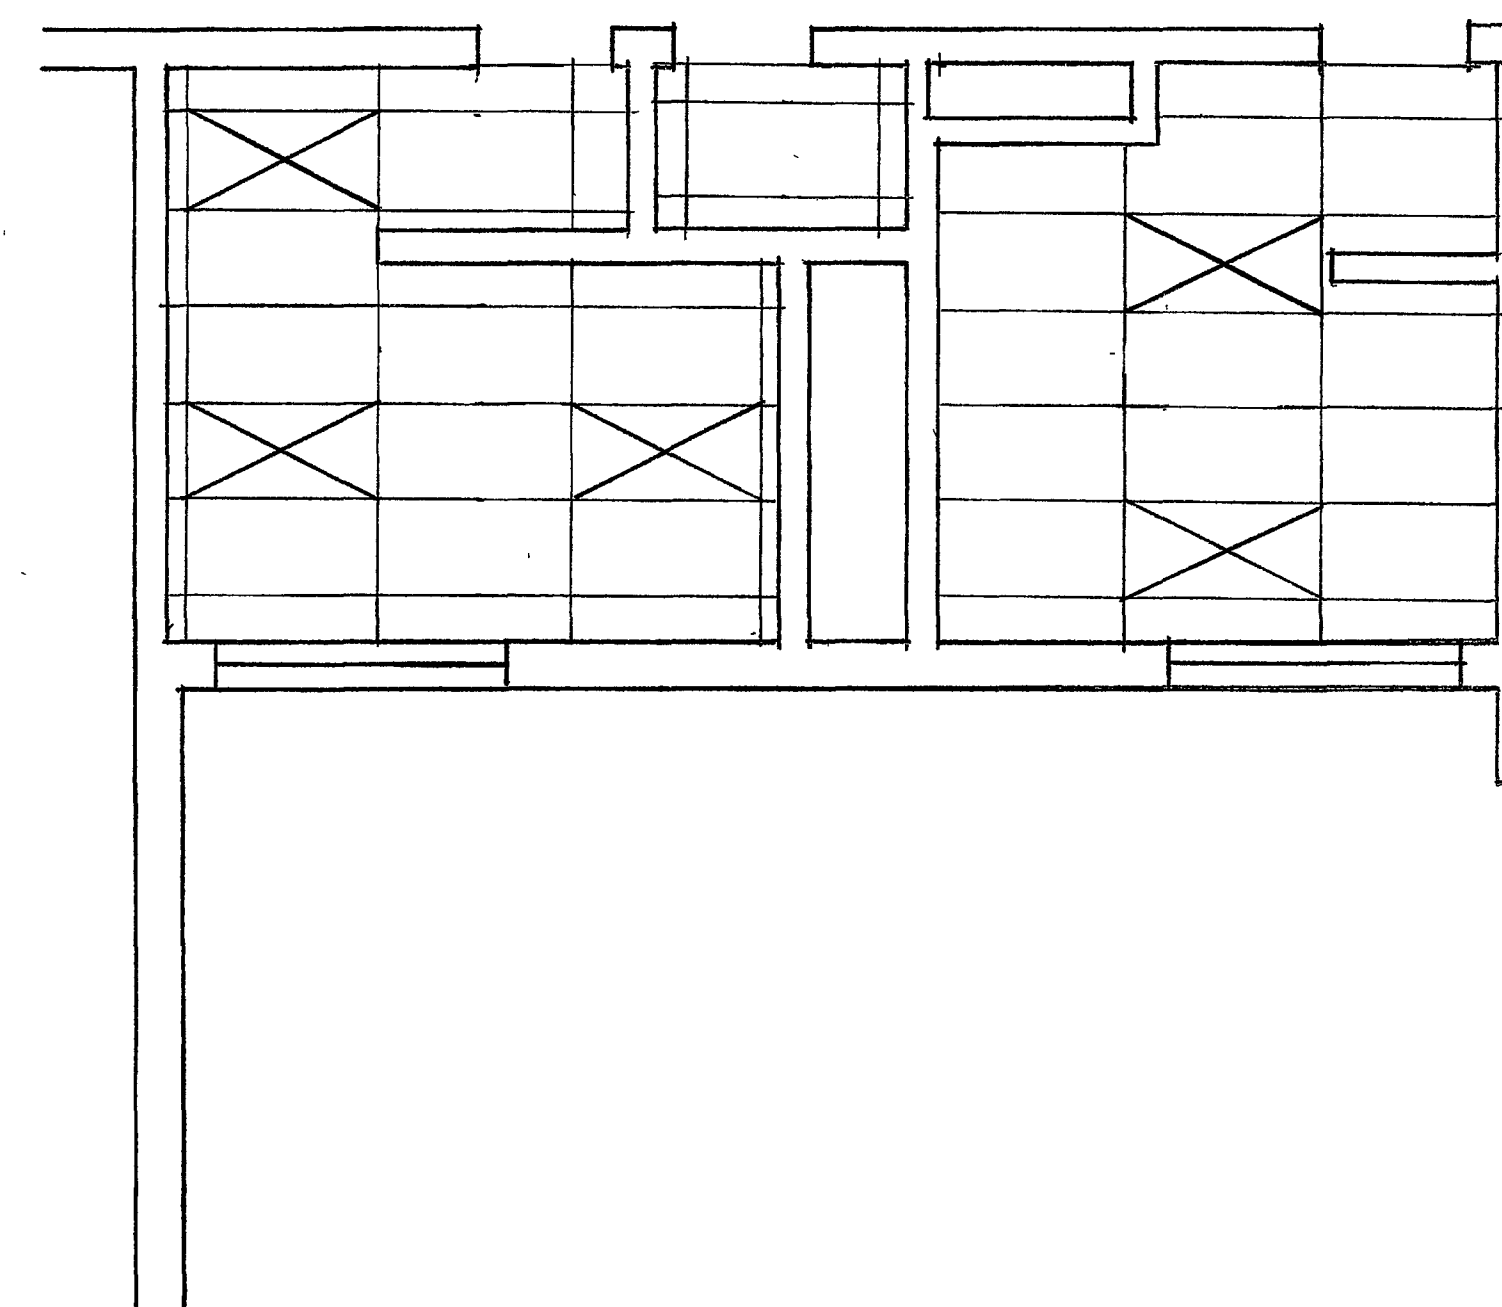

GANG TOILETS
WEST OF PRINCIPALS OFFICE

JACKSON PUBLIC SCHOOL DISTRICT

JACKSON, MISSISSIPPI

SITE: MARSHALL ELEMENTARY SCHOOL

TOILET RENOVATIONS

SITE ADDRESS:

2909 OAK FOREST DRIVE

DRAWN BY: WM

DATE: 1.18.05

VERIFY ALL DIMENSIONS

PRIOR TO CONSTRUCTION

FINAL

APPROVED: *[Signature]*

DATE: 1/25/11

REVISED:

DATE:

SHEET: 3

OF: 3

DRAWING NUMBER 5019